



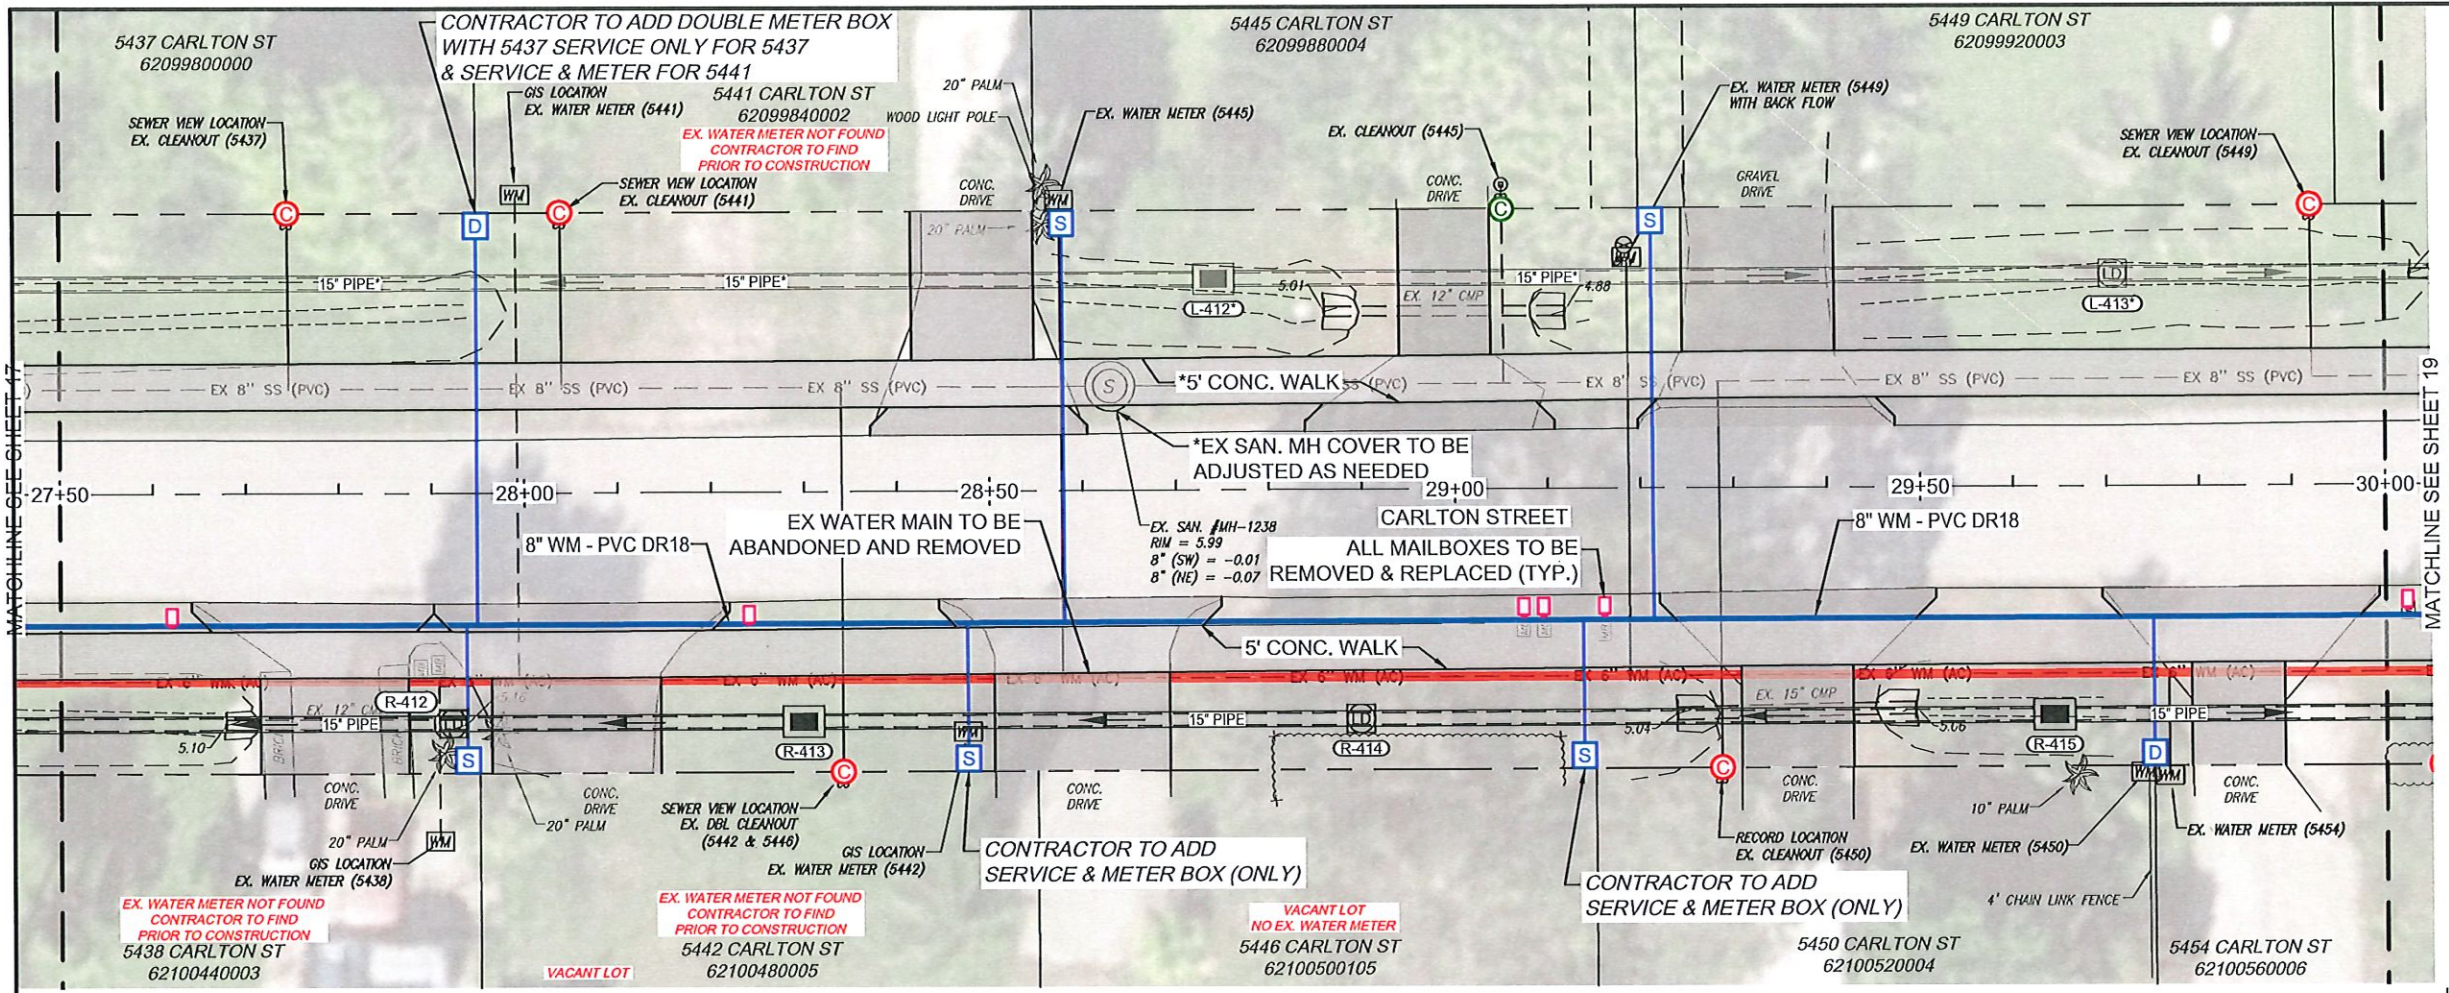

NOTES:

- REPLACE EX. CROSSWALK, DETECTABLE WARNING STRIPS AND ROAD STRIPING IN MILLING AND TRENCH AREAS AS REQUIRED.
- EX. DRAINAGE INFRASTRUCTURE TO BE REMOVED WHERE NEW DRAINAGE IS BEING INSTALLED. (TYP.)
- EX. AC WATER MAIN TO BE ABANDONED AND REMOVED.
- ALL CLEAN-OUTS TO BE ADJUSTED TO FINISH GRADE PER COLLIER COUNTY STANDARDS (TYP.).
- EX. SANITARY MANHOLE RIMS MUST BE ADJUSTED TO PROPOSED SIDEWALK GRADES.
- ALL WATER METERS WILL BE REPLACED AND RELOCATED TO THE RIGHT-OF-WAY PROPERTY CORNERS PER COLLIER COUNTY STANDARDS. ALL NEW WATER METERS AND BOXES TO BE PROVIDED BY COLLIER COUNTY (TYP.).
- *REPRESENTS THE ALTERNATE PORTIONS OF THIS PROJECT. ALL DRIVEWAY, SIDEWALK, AND DRAINAGE ON THE NORTH/LEFT SIDE OF CARLTON WILL BE PART OF AN ALTERNATE PROJECT UNLESS OTHERWISE NOTED.

INTENDED DISPLAY SCALE: 1"=20'

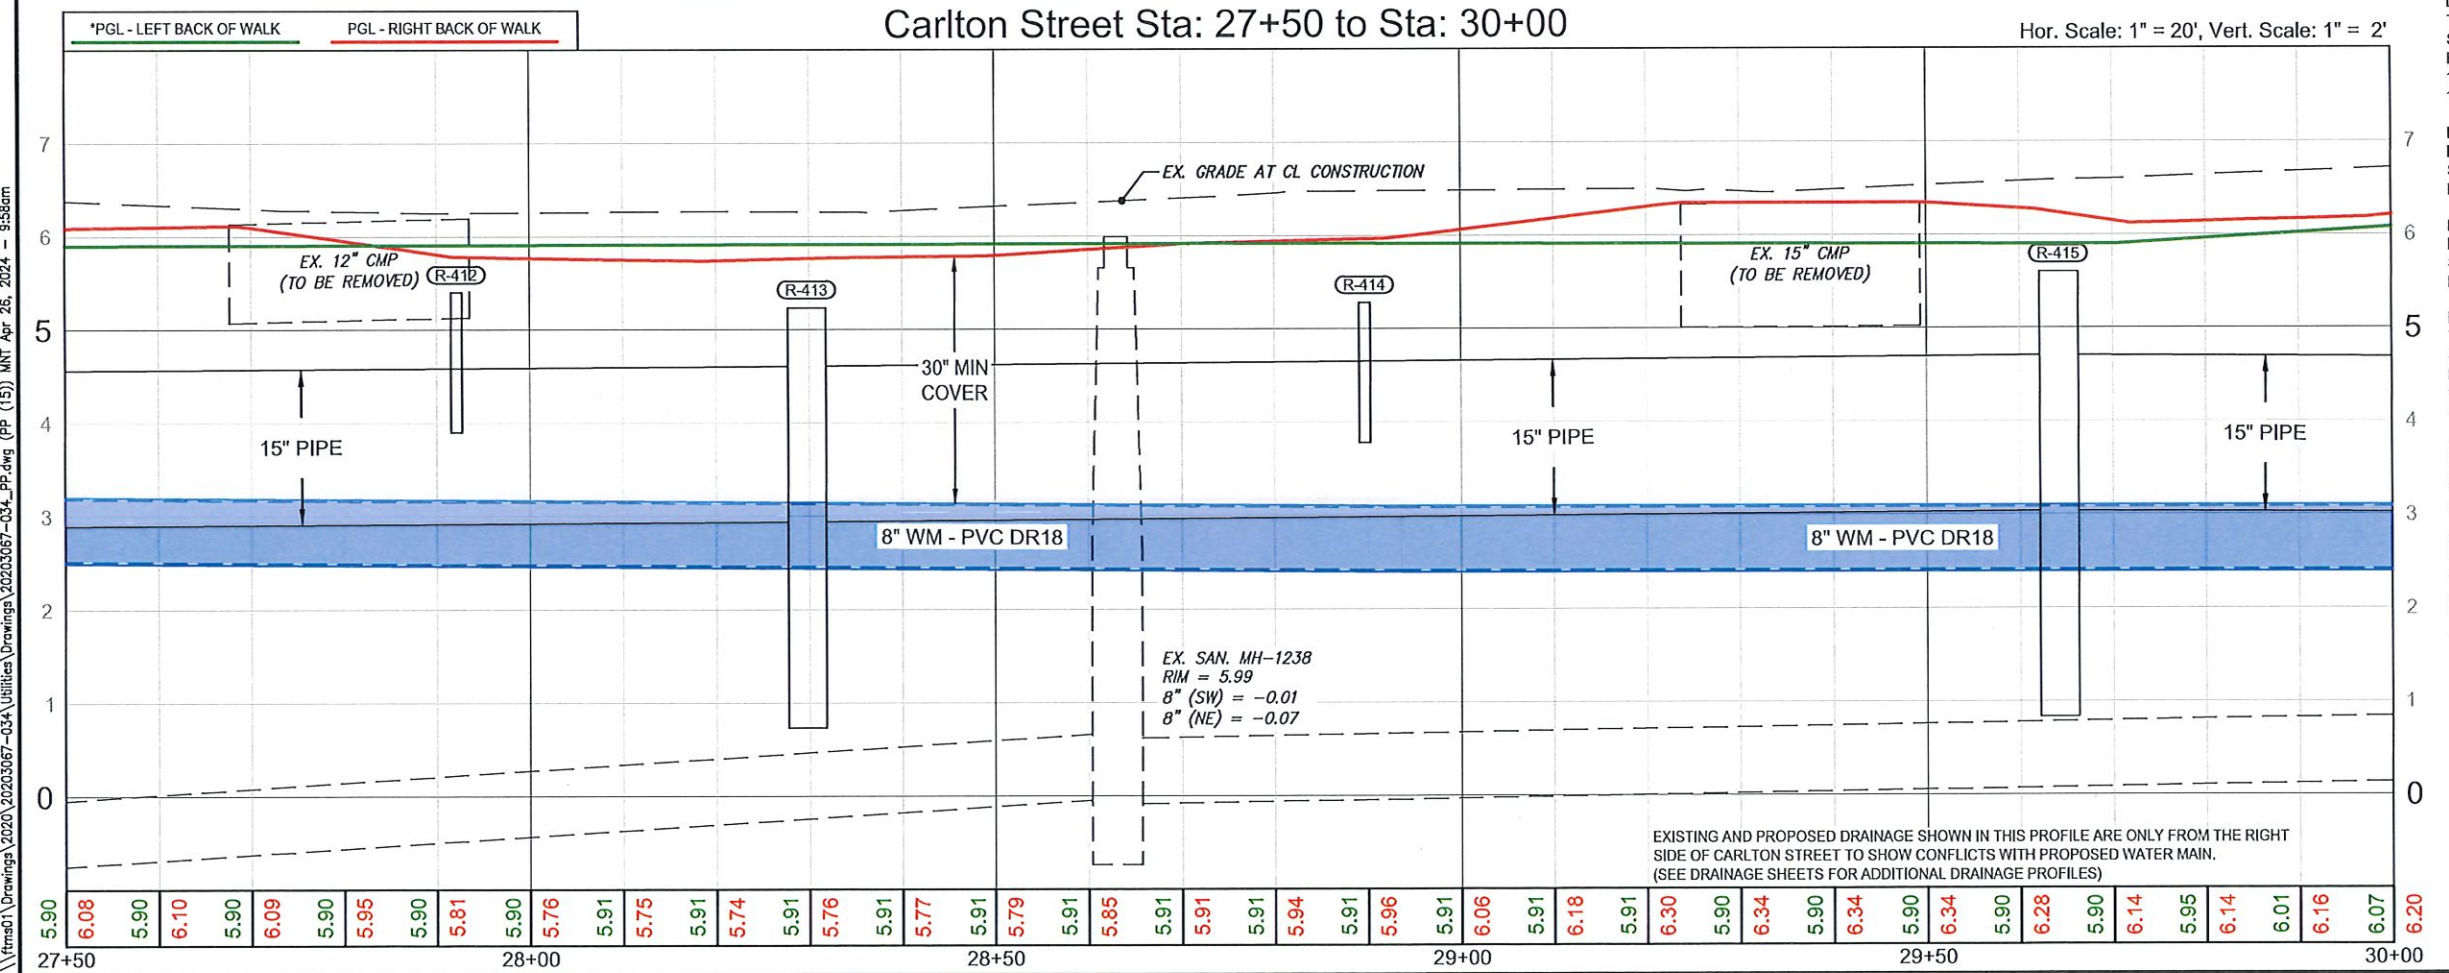

L-412*
TYPE C INLET
STA 28+74.29, 22.60 L
RIM = 4.83, BOTTOM = 0.83
15" PIPE* (SW) = 2.75
15" PIPE* (NE) = 2.75

L-413*
IN-LINE DRAIN
STA 29+70.91, 22.68 L
RIM = 4.90, BOTTOM = -5.00

R-412
IN-LINE
STA 27+92.18, 24.65 R
RIM = 5.40, BOTTOM = -5.00

R-413
TYPE C INLET
STA 28+29.79, 24.60 R
RIM = 5.23, BOTTOM = 1.23
15" PIPE (NE) = 3.15
15" PIPE (SW) = 3.15

R-414
IN-LINE
STA 28+89.75, 24.54 R
RIM = 5.28, BOTTOM = -5.00

R-415
TYPE C INLET
STA 29+64.21, 24.45 R
RIM = 5.60, BOTTOM = 1.33
15" PIPE (SW) = 3.25
15" PIPE (NE) = 3.25

EXISTING AND PROPOSED DRAINAGE SHOWN IN THIS PROFILE ARE ONLY FROM THE RIGHT SIDE OF CARLTON STREET TO SHOW CONFLICTS WITH PROPOSED WATER MAIN. (SEE DRAINAGE SHEETS FOR ADDITIONAL DRAINAGE PROFILES)

JOHNSON ENGINEERING

JOHNSON ENGINEERING, INC.
2350 STANFORD COURT
NAPLES, FLORIDA 34112
PHONE: (239) 434-0333
E.B. #642 & L.B. #642

Collier County


Carlton Street Sidewalk and Utility Improvements
Collier County, Florida

REVISIONS	
NO.	DESCRIPTION

DATE: April 26, 2024
PROJECT NO. 20203067-034
FILE NO. 50-29-26
SCALE: As Shown


Construction Plans
Utility Plan & Profile
Carlton Street
Sta 27+50 to 30+00

SHEET NUMBER
18

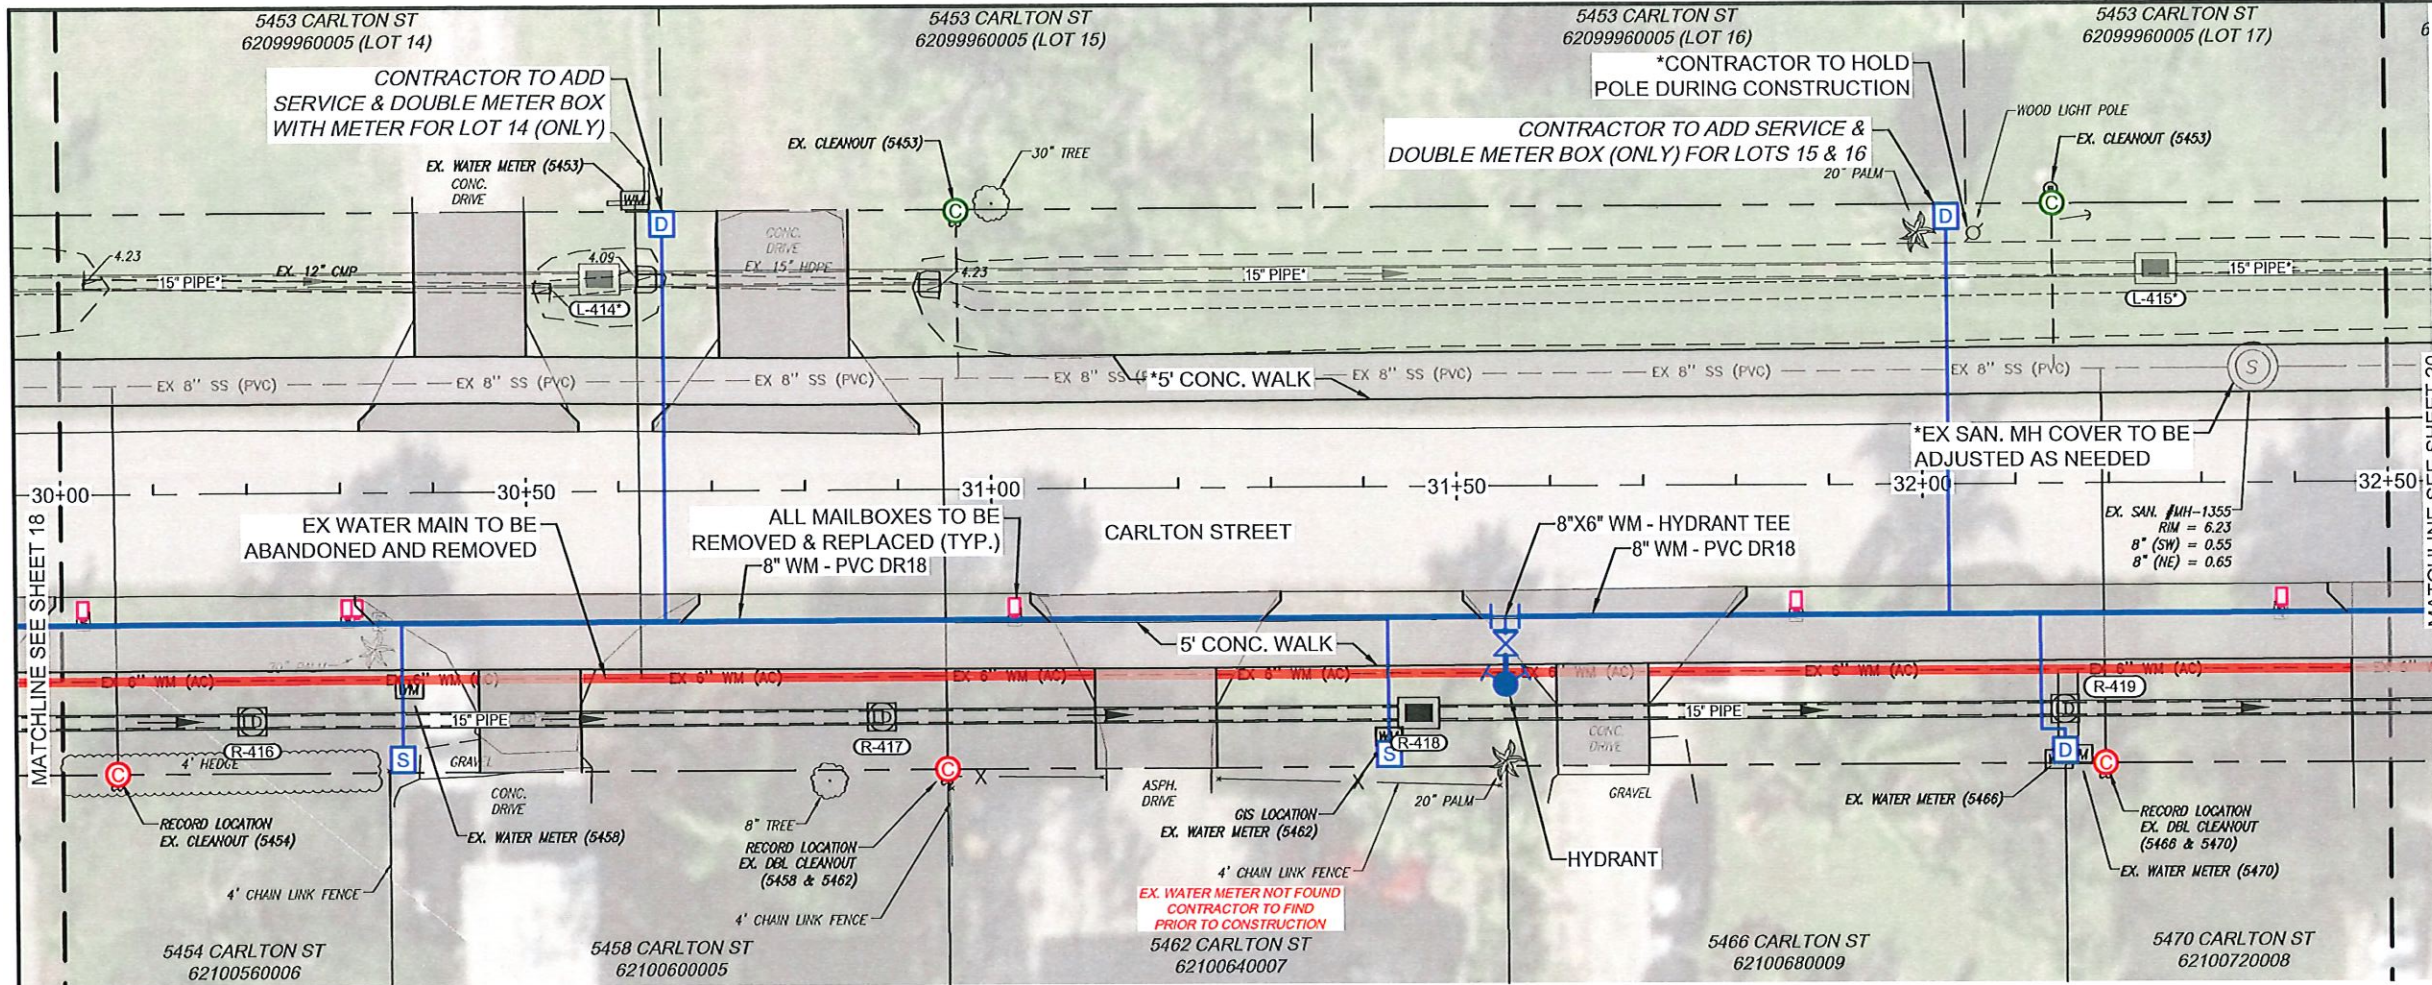

- NOTES:
- REPLACE EX. CROSSWALK, DETECTABLE WARNING STRIPS AND ROAD STRIPING IN MILLING AND TRENCH AREAS AS REQUIRED.
 - EX. DRAINAGE INFRASTRUCTURE TO BE REMOVED WHERE NEW DRAINAGE IS BEING INSTALLED. (TYP.)
 - EX. AC WATER MAIN TO BE ABANDONED AND REMOVED.
 - ALL CLEAN-OUTS TO BE ADJUSTED TO FINISH GRADE PER COLLIER COUNTY STANDARDS (TYP.).
 - EX. SANITARY MANHOLE RIMS MUST BE ADJUSTED TO PROPOSED SIDEWALK GRADES.
 - ALL WATER METERS WILL BE REPLACED AND RELOCATED TO THE RIGHT-OF-WAY PROPERTY CORNERS PER COLLIER COUNTY STANDARDS. ALL NEW WATER METERS AND BOXES TO BE PROVIDED BY COLLIER COUNTY (TYP.).
 - *REPRESENTS THE ALTERNATE PORTIONS OF THIS PROJECT. ALL DRIVEWAY, SIDEWALK, AND DRAINAGE ON THE NORTH / LEFT SIDE OF CARLTON WILL BE PART OF AN ALTERNATE PROJECT UNLESS OTHERWISE NOTED.

- L-414*
TYPE C INLET
STA 30+58.21, 22.76 L
RIM = 5.20, BOTTOM = 0.73
15" PIPE* (SW) = 2.65
15" PIPE* (NE) = 2.65
- L-415*
TYPE C INLET
STA 32+25.29, 22.91 L
RIM = 5.20, BOTTOM = 0.63
15" PIPE* (SW) = 2.55
15" PIPE* (NE) = 2.55
- R-416
IN-LINE
STA 30+20.30, 24.39 R
RIM = 5.70, BOTTOM = -5.00
- R-417
IN-LINE
STA 30+87.96, 24.31 R
RIM = 5.90, BOTTOM = -5.00
- R-418
TYPE C INLET
STA 31+45.65, 24.25 R
RIM = 5.95, BOTTOM = 1.13
15" PIPE (SW) = 3.15
15" PIPE (NE) = 3.15
- R-419
IN-LINE
STA 32+15, 24.17 R
RIM = 5.87, BOTTOM = -5.00

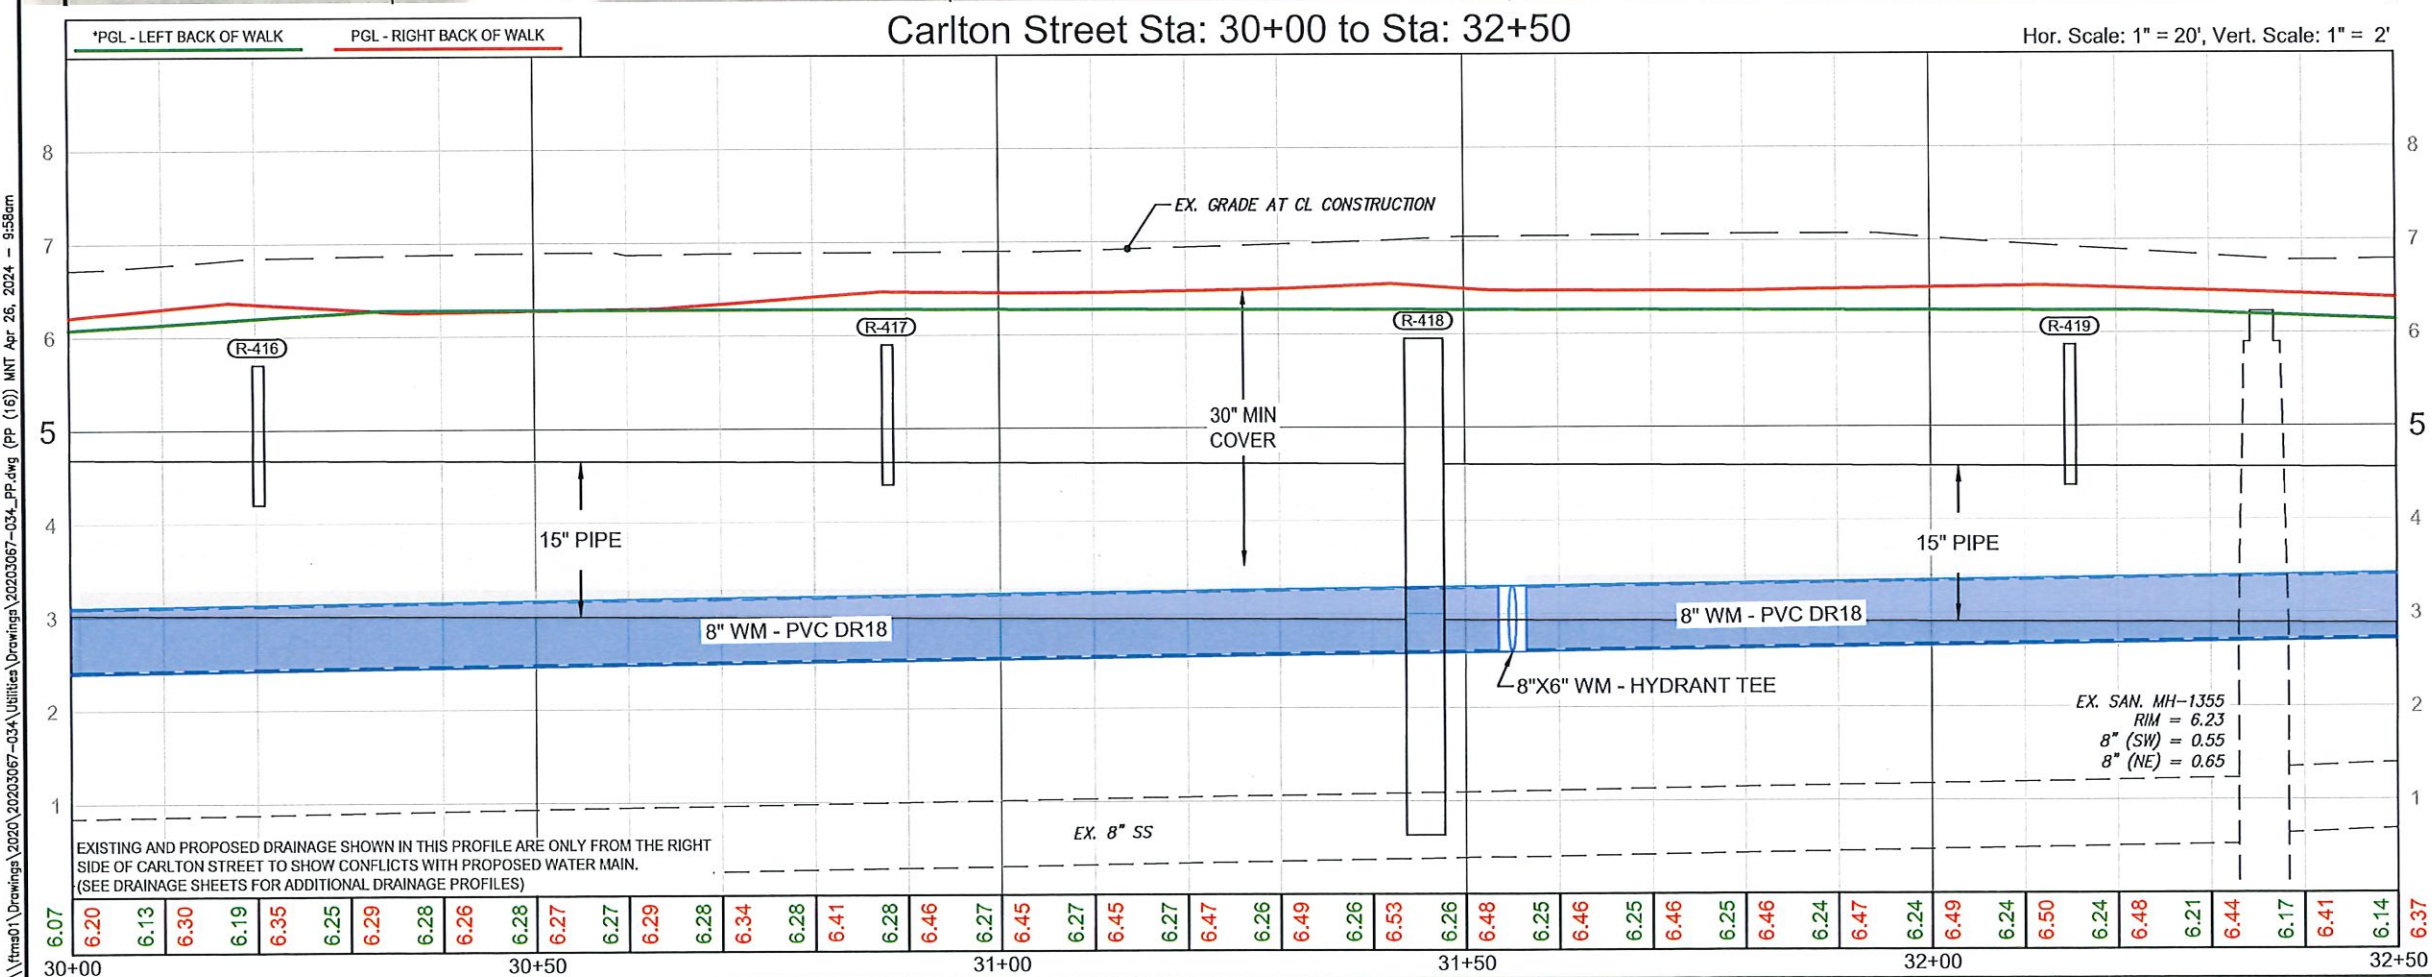

- EX. SAN. MH-1355
RIM = 6.23
8" (SW) = 0.55
8" (NE) = 0.65



Carlton Street Sidewalk
and Utility Improvements
Collier County, Florida


REVISIONS	
NO.	DESCRIPTION

DATE: April 26, 2024
PROJECT NO. 20203067-034
FILE NO. 50-29-26
SCALE: As Shown

Construction Plans
Utility Plan & Profile
Carlton Street
Sta 30+00 to 32+50


Carlton Street Sidewalk
and Utility Improvements
Collier County, Florida0 5 10 20
INTENDED DISPLAY
SCALE: 1"=20'

- NOTES:
- REPLACE EX. CROSSWALK, DETECTABLE WARNING STRIPS AND ROAD STRIPING IN MILLING AND TRENCH AREAS AS REQUIRED.
 - EX. DRAINAGE INFRASTRUCTURE TO BE REMOVED WHERE NEW DRAINAGE IS BEING INSTALLED. (TYP.)
 - EX. AC WATER MAIN TO BE ABANDONED AND REMOVED.
 - ALL CLEAN-OUTS TO BE ADJUSTED TO FINISH GRADE PER COLLIER COUNTY STANDARDS (TYP.).
 - EX. SANITARY MANHOLE RIMS MUST BE ADJUSTED TO PROPOSED SIDEWALK GRADES.
 - ALL WATER METERS WILL BE REPLACED AND RELOCATED TO THE RIGHT-OF-WAY PROPERTY CORNERS PER COLLIER COUNTY STANDARDS. ALL NEW WATER METERS AND BOXES TO BE PROVIDED BY COLLIER COUNTY (TYP.).
 - REPRESENTS THE ALTERNATE PORTIONS OF THIS PROJECT. ALL DRIVEWAY, SIDEWALK, AND DRAINAGE ON THE NORTH / LEFT SIDE OF CARLTON WILL BE PART OF AN ALTERNATE PROJECT UNLESS OTHERWISE NOTED.

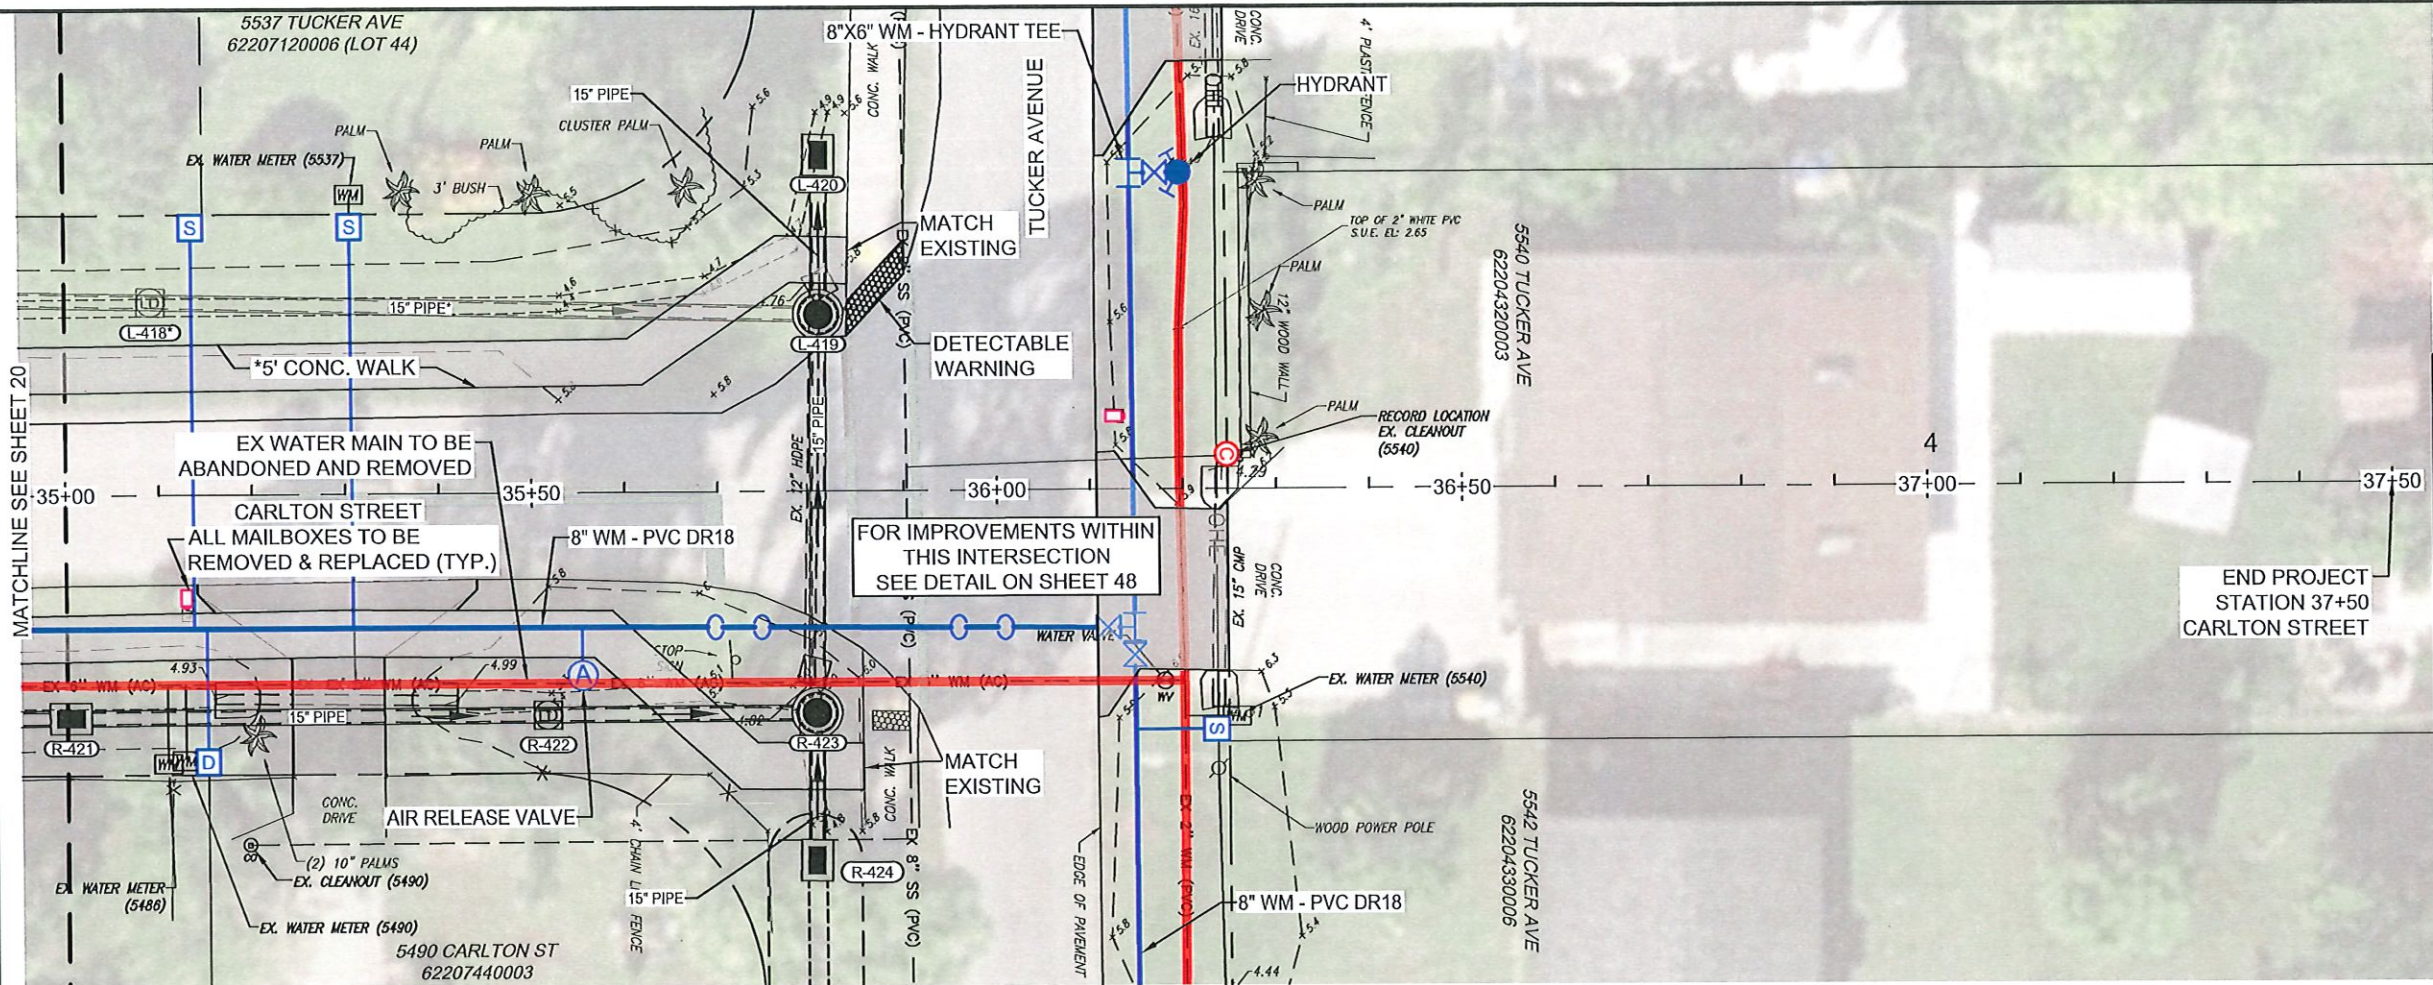END PROJECT
STATION 37+50
CARLTON STREET

Carlton Street Sta: 35+00 to Sta: 37+50

Hor. Scale: 1" = 20', Vert. Scale: 1" = 2'

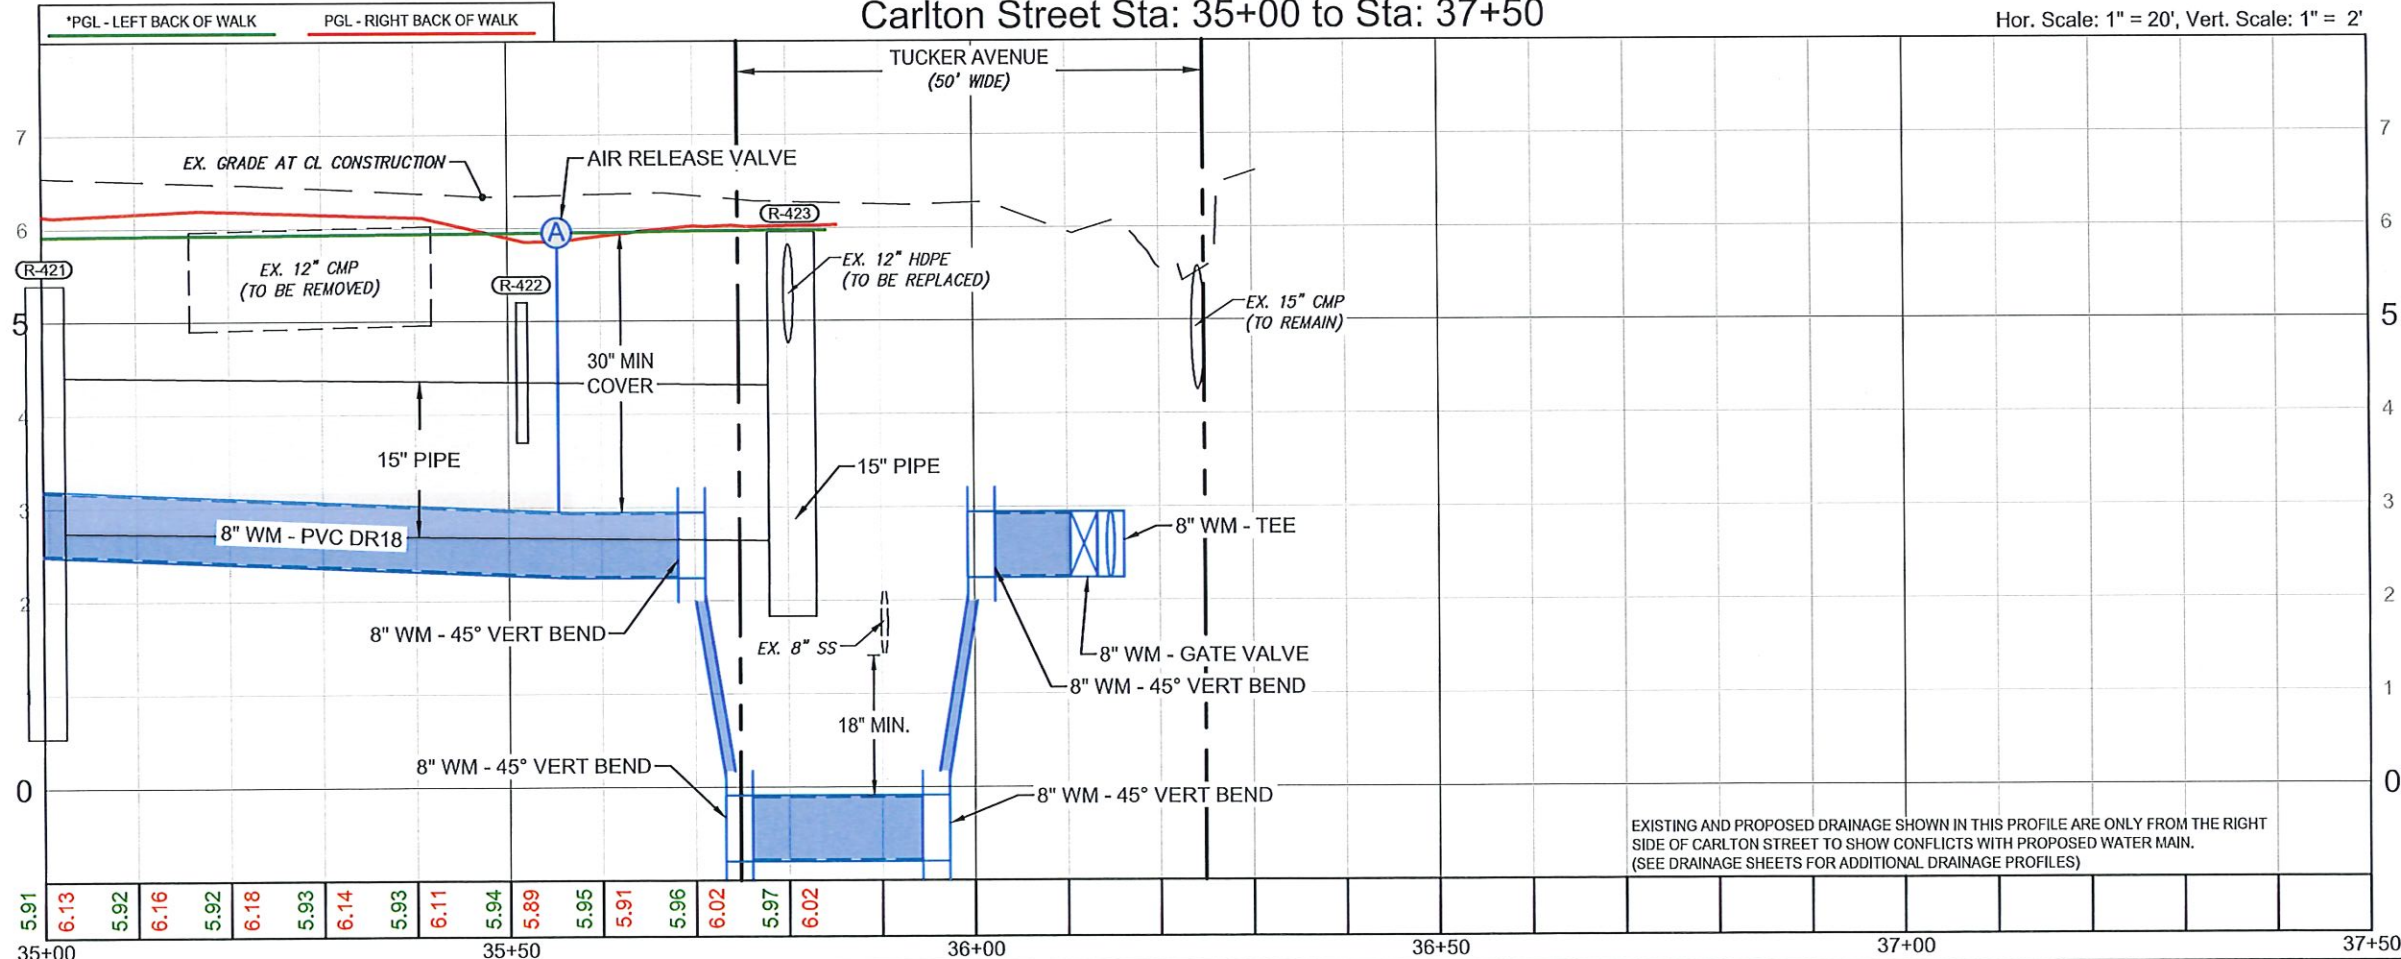


- L-419
JUNCTION BOX
STA 35+81.09, 18.93 L
RIM = 5.97, BOTTOM = 2.33
15" PIPE (SE) = 2.25
15" PIPE (NW) = 2.25
15" PIPE (SW) = 2.35
- L-420
TYPE C INLET
STA 35+81.28, 36.03 L
RIM = 4.98, BOTTOM = 2.33
15" PIPE (SE) = 2.25
- R-421
TYPE C INLET
STA 35+00.32, 23.85 R
RIM = 5.39, BOTTOM = 1.03
15" PIPE (SW) = 2.95
15" PIPE (NE) = 2.95
- R-422
IN-LINE
STA 35+51.53, 23.79 R
RIM = 5.20, BOTTOM = -5.00
- R-423
JUNCTION BOX
STA 35+80.50, 23.76 R
RIM = 5.95, BOTTOM = 2.33
15" PIPE (SE) = 2.25
15" PIPE (NW) = 2.25
15" PIPE (SW) = 2.85
- R-424
TYPE C INLET
STA 35+80.28, 39.56 R
RIM = 4.93, BOTTOM = 2.33
15" PIPE (NW) = 2.25

EXISTING AND PROPOSED DRAINAGE SHOWN IN THIS PROFILE ARE ONLY FROM THE RIGHT
SIDE OF CARLTON STREET TO SHOW CONFLICTS WITH PROPOSED WATER MAIN.
(SEE DRAINAGE SHEETS FOR ADDITIONAL DRAINAGE PROFILES)REVISIONS
DESCRIPTIONDATE: April 26, 2024
PROJECT NO. 20203067-034
FILE NO. 50-29-26
SCALE: As ShownConstruction Plans
Utility Plan & Profile
Carlton Street
Sta 35+00 to 37+50

SHEET NUMBER

21

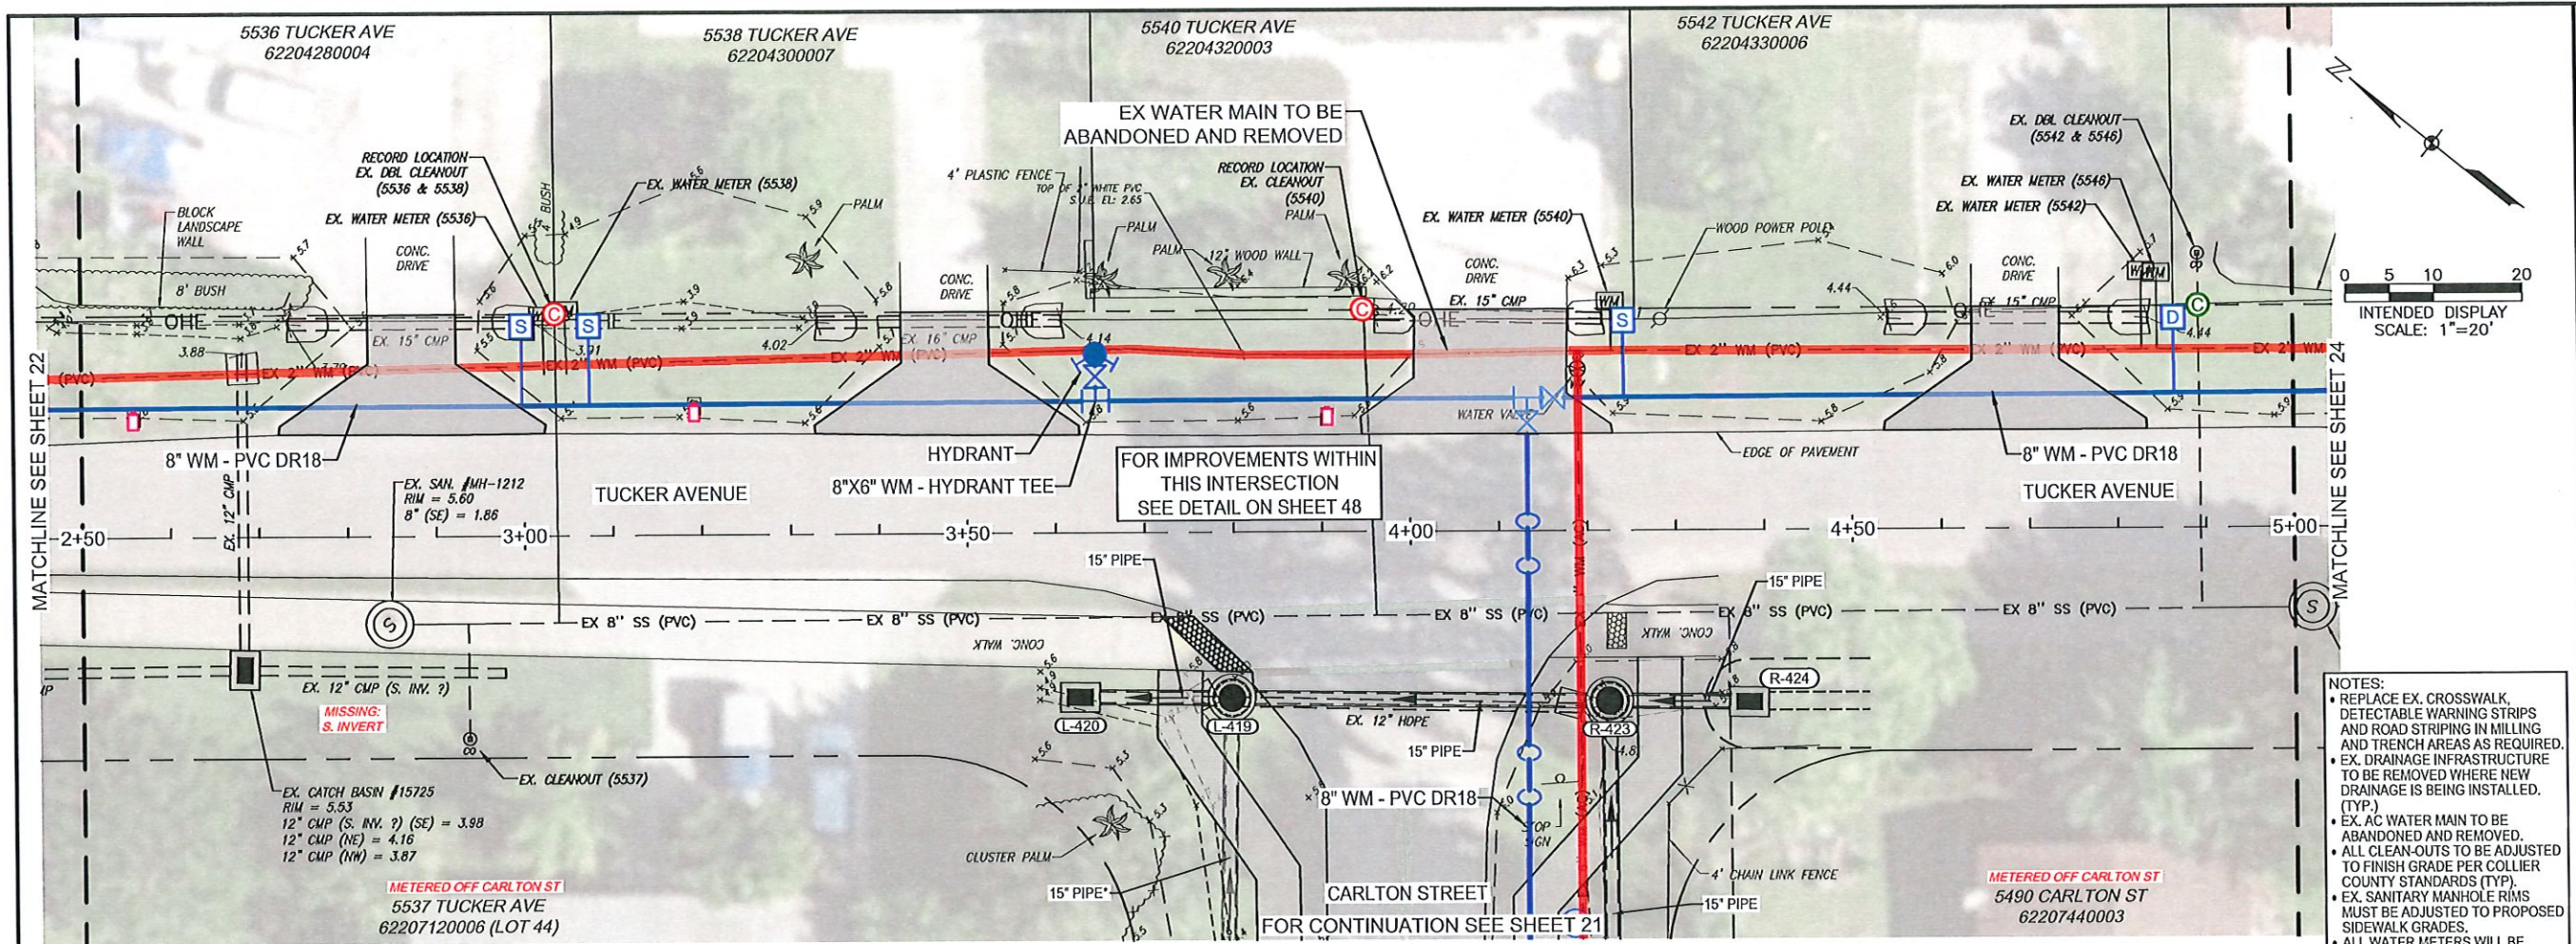

JOHNSON ENGINEERING
JOHNSON ENGINEERING, INC.
2350 STANFORD COURT
NAPLES, FLORIDA 34112
PHONE: (239) 434-0333
E.B. #642 & L.B. #642




Carlton Street Sidewalk
and Utility Improvements
Collier County, Florida

- NOTES:
- REPLACE EX. CROSSWALK, DETECTABLE WARNING STRIPS AND ROAD STRIPING IN MILLING AND TRENCH AREAS AS REQUIRED.
 - EX. DRAINAGE INFRASTRUCTURE TO BE REMOVED WHERE NEW DRAINAGE IS BEING INSTALLED. (TYP.)
 - EX. AC WATER MAIN TO BE ABANDONED AND REMOVED.
 - ALL CLEAN-OUTS TO BE ADJUSTED TO FINISH GRADE PER COLLIER COUNTY STANDARDS (TYP.)
 - EX. SANITARY MANHOLE RIMS MUST BE ADJUSTED TO PROPOSED SIDEWALK GRADES.
 - ALL WATER METERS WILL BE REPLACED AND RELOCATED TO THE RIGHT-OF-WAY PROPERTY CORNERS PER COLLIER COUNTY STANDARDS. ALL NEW WATER METERS AND BOXES TO BE PROVIDED BY COLLIER COUNTY (TYP.)
 - * REPRESENTS THE ALTERNATE PORTIONS OF THIS PROJECT. ALL DRIVEWAY, SIDEWALK, AND DRAINAGE ON THE NORTH / LEFT SIDE OF CARLTON WILL BE PART OF AN ALTERNATE PROJECT UNLESS OTHERWISE NOTED.

Tucker Avenue Sta: 2+50 to Sta: 5+00

Hor. Scale: 1" = 20', Vert. Scale: 1" = 2'

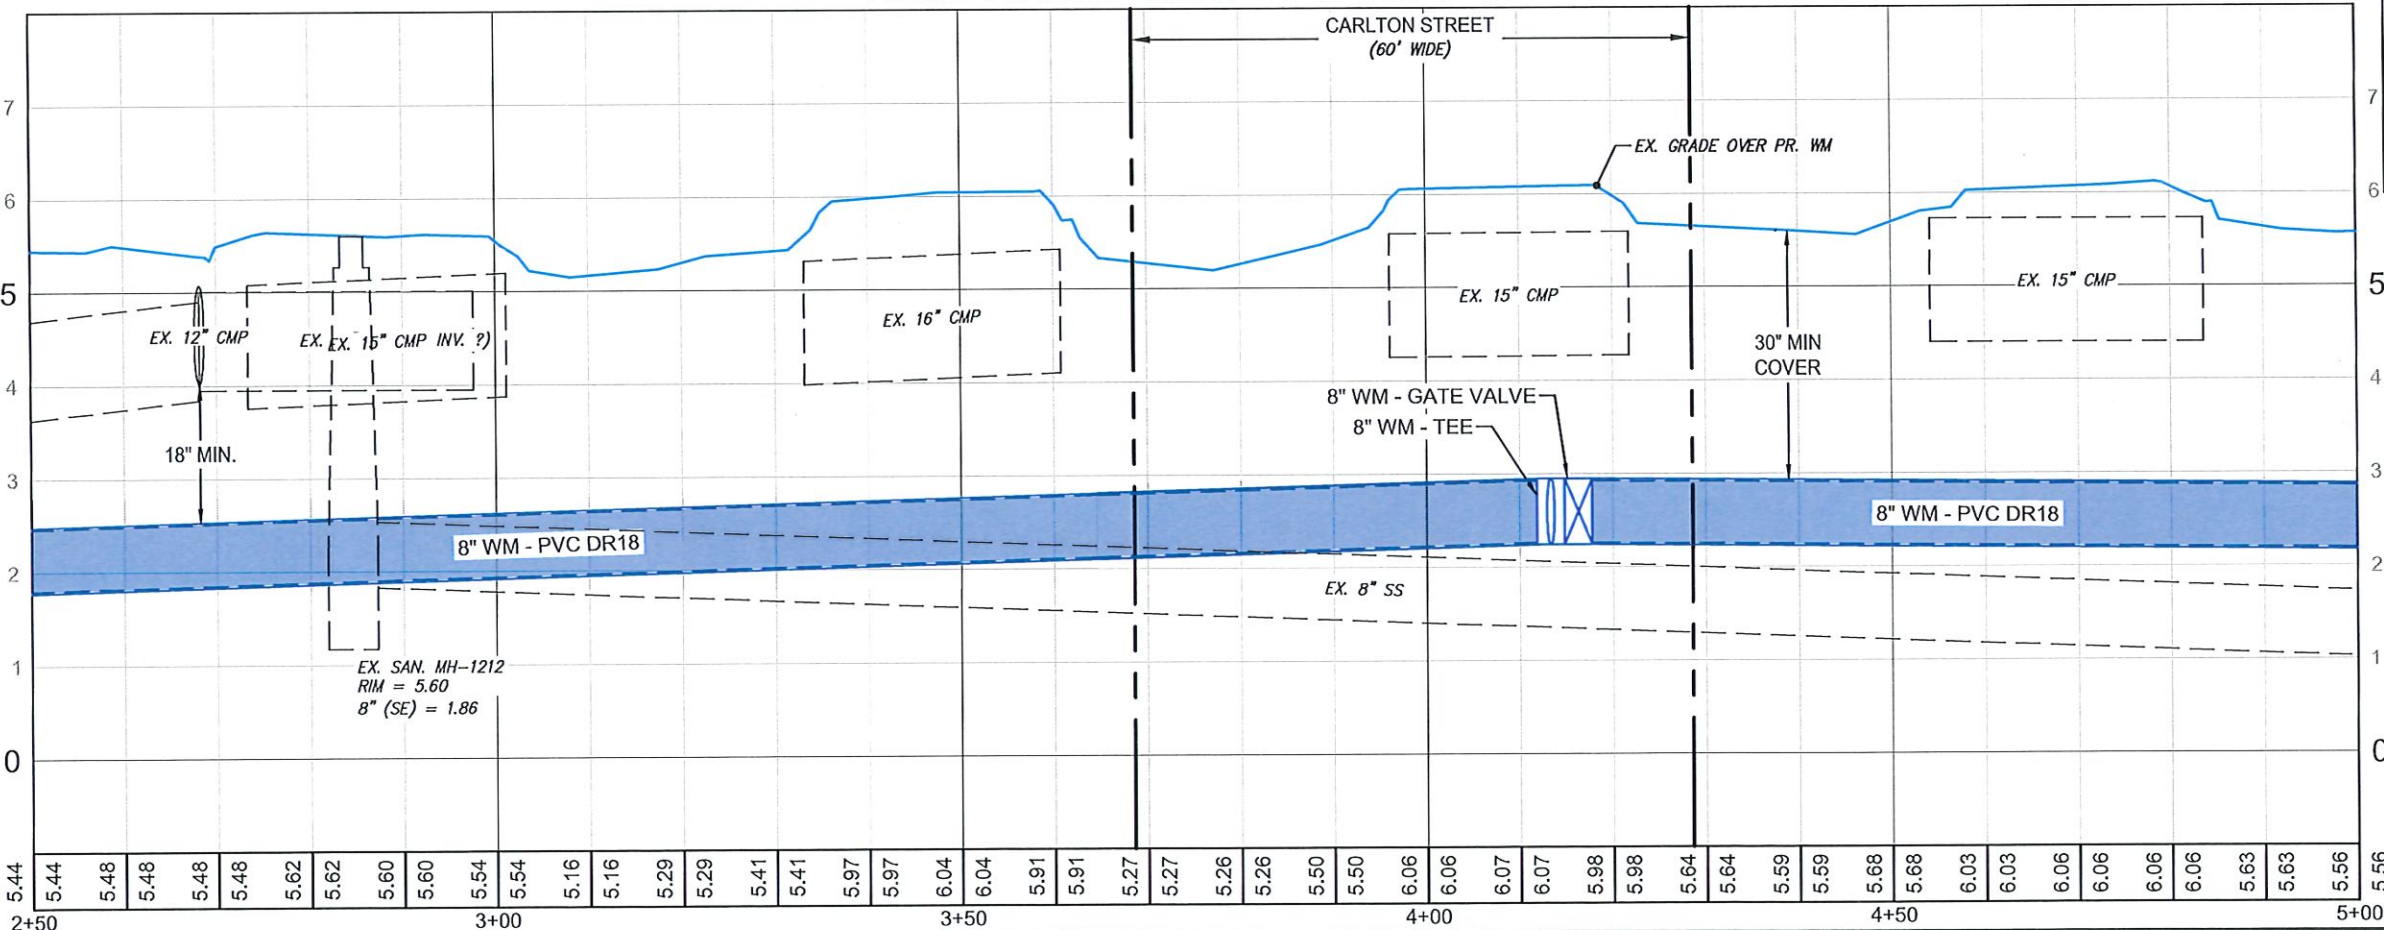

- R-423
JUNCTION BOX
STA 35+80.50, 23.76 R
RIM = 5.95, BOTTOM = 2.33
15" PIPE (SE) = 2.25
15" PIPE (NW) = 2.25
15" PIPE (SW) = 2.85
- R-424
TYPE C INLET
STA 35+80.28, 39.56 R
RIM = 4.93, BOTTOM = 2.33
15" PIPE (NW) = 2.25

REVISIONS	
NO.	DESCRIPTION

DATE: April 26, 2024
PROJECT NO. 20203067-034
FILE NO. 50-29-26
SCALE: As Shown


Construction Plans
Utility Plan & Profile
Tucker Avenue
Sta 2+50 to 5+00

[illegible]


Construction Plans
Utility Plan & Profile
Tucker Avenue
Sta 5+00 to 7+70

SHEET NUMBER

24

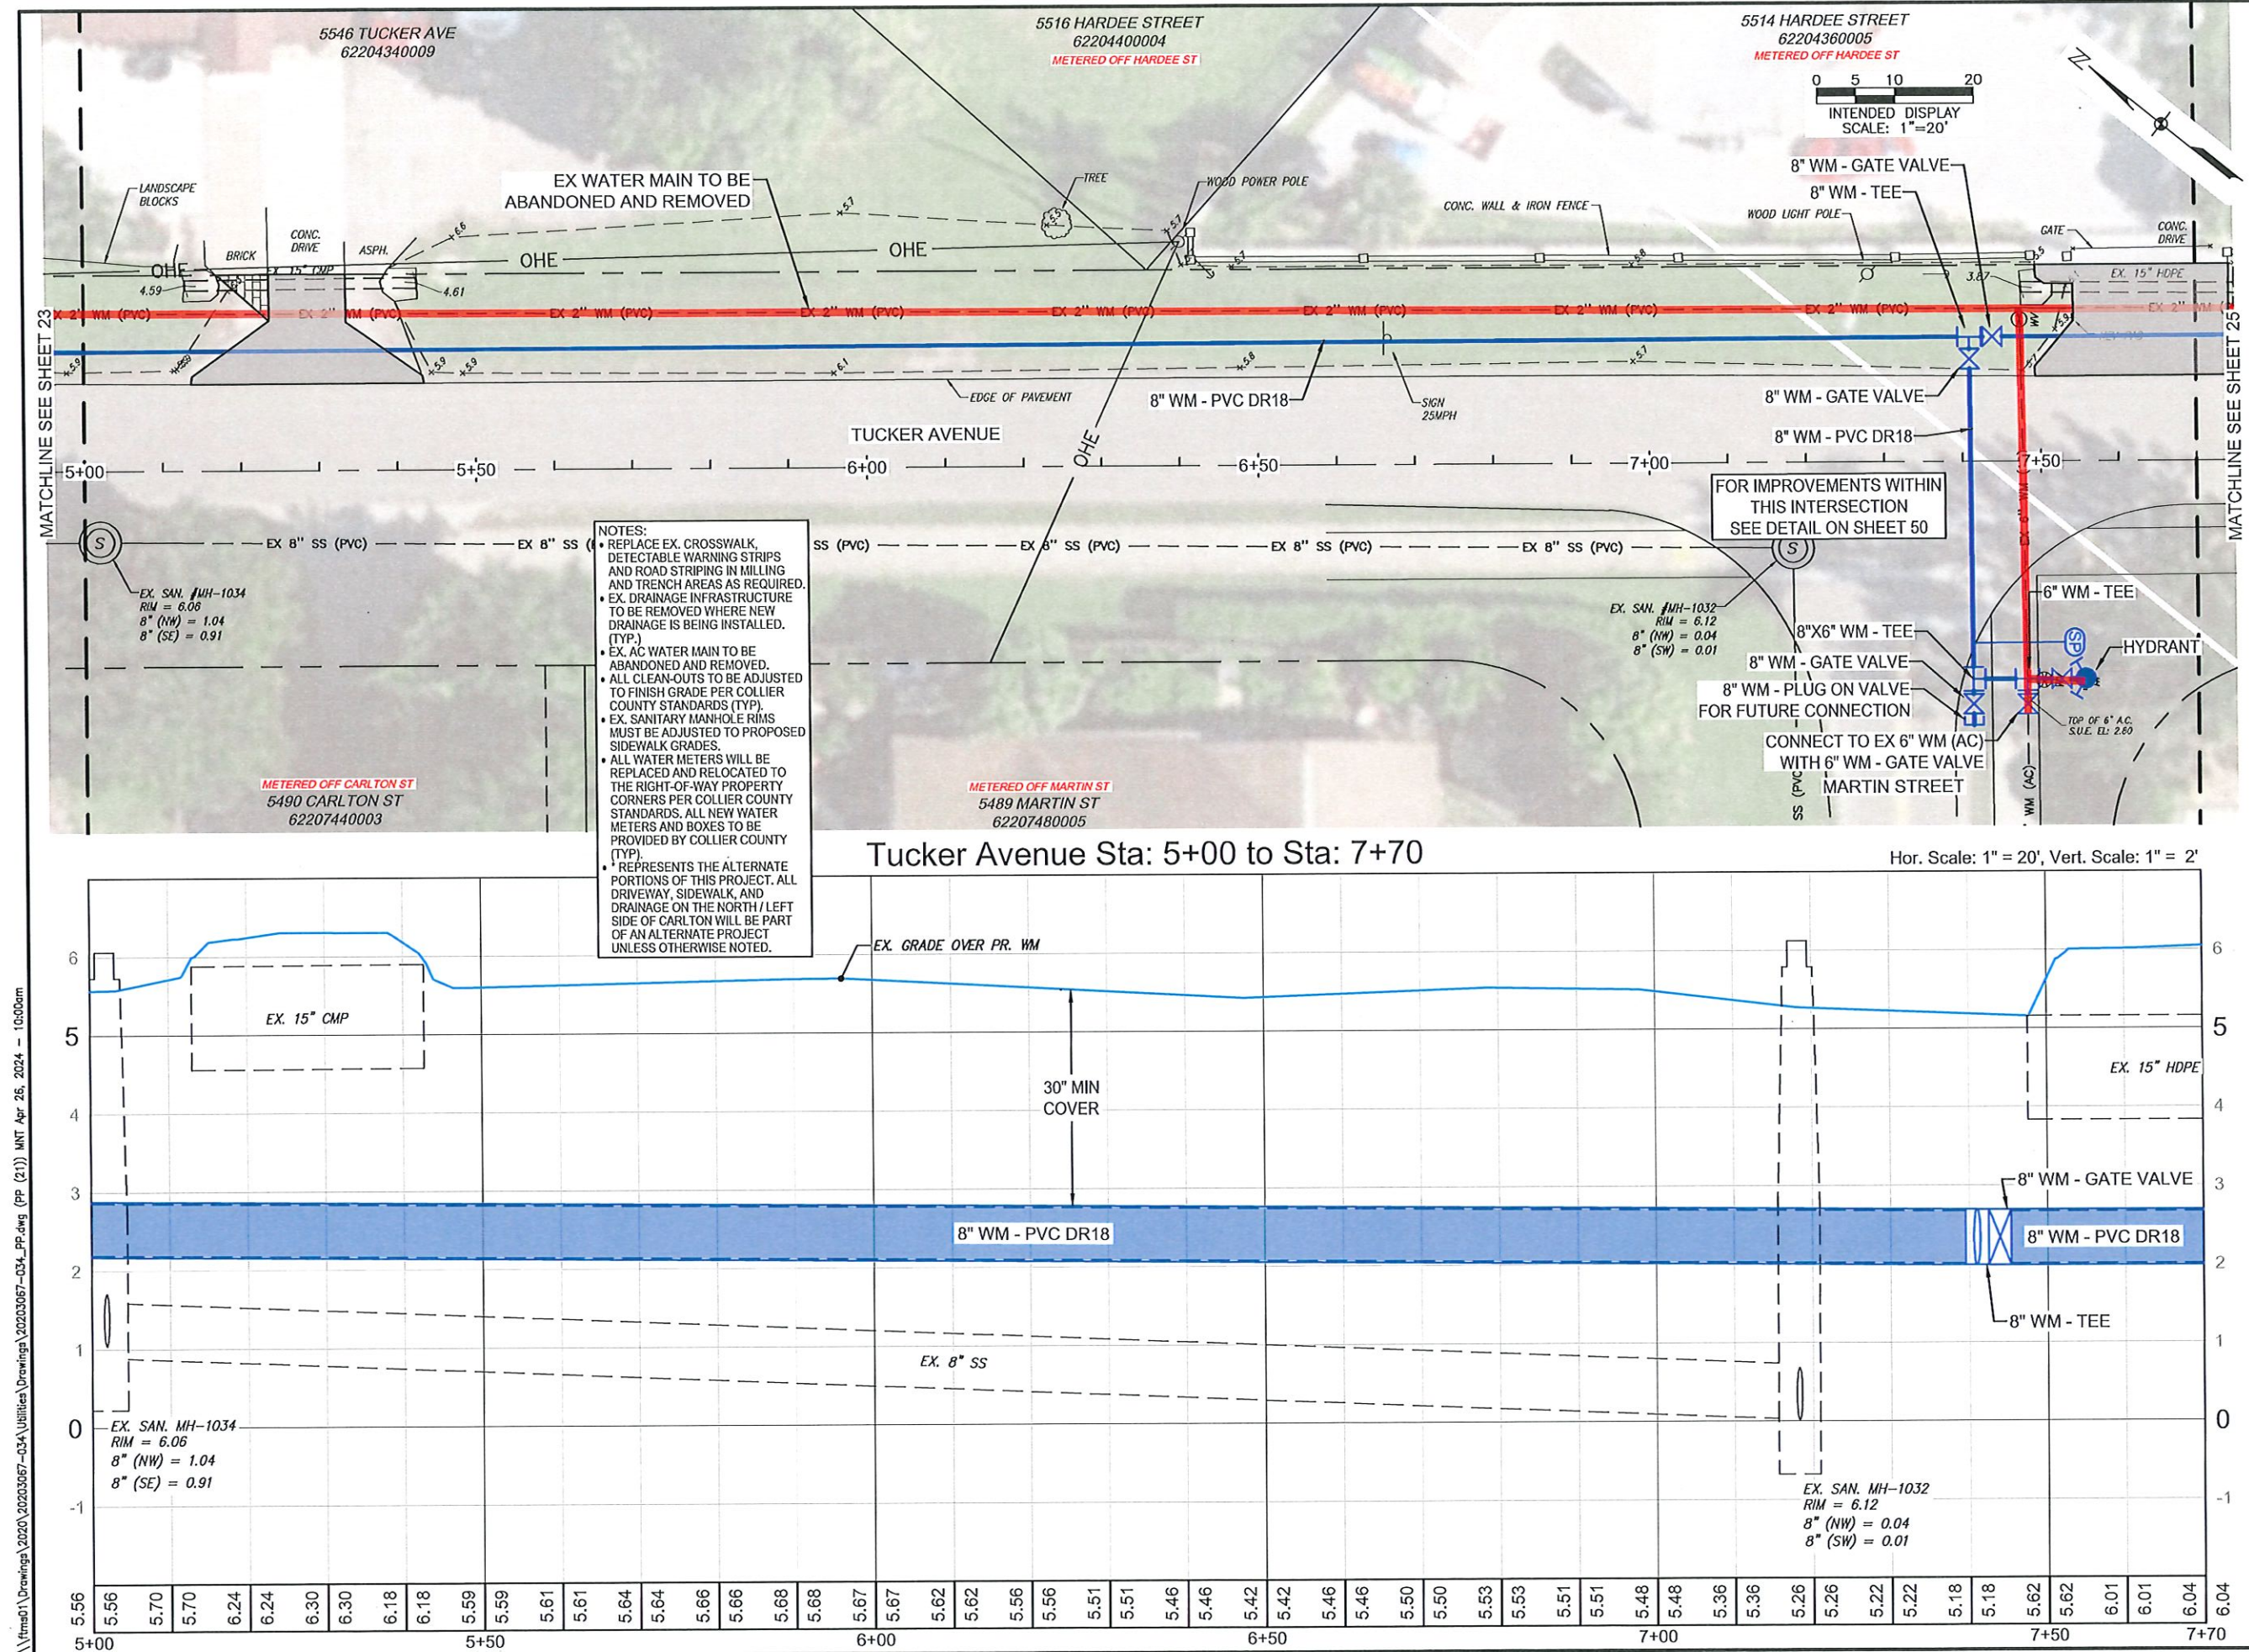


\\fms01\Drawings\2020\20203067-034\Utilities\Drawings\20203067-034_PP.dwg (PP (22)) MNT Apr 26, 2024 - 10:00am

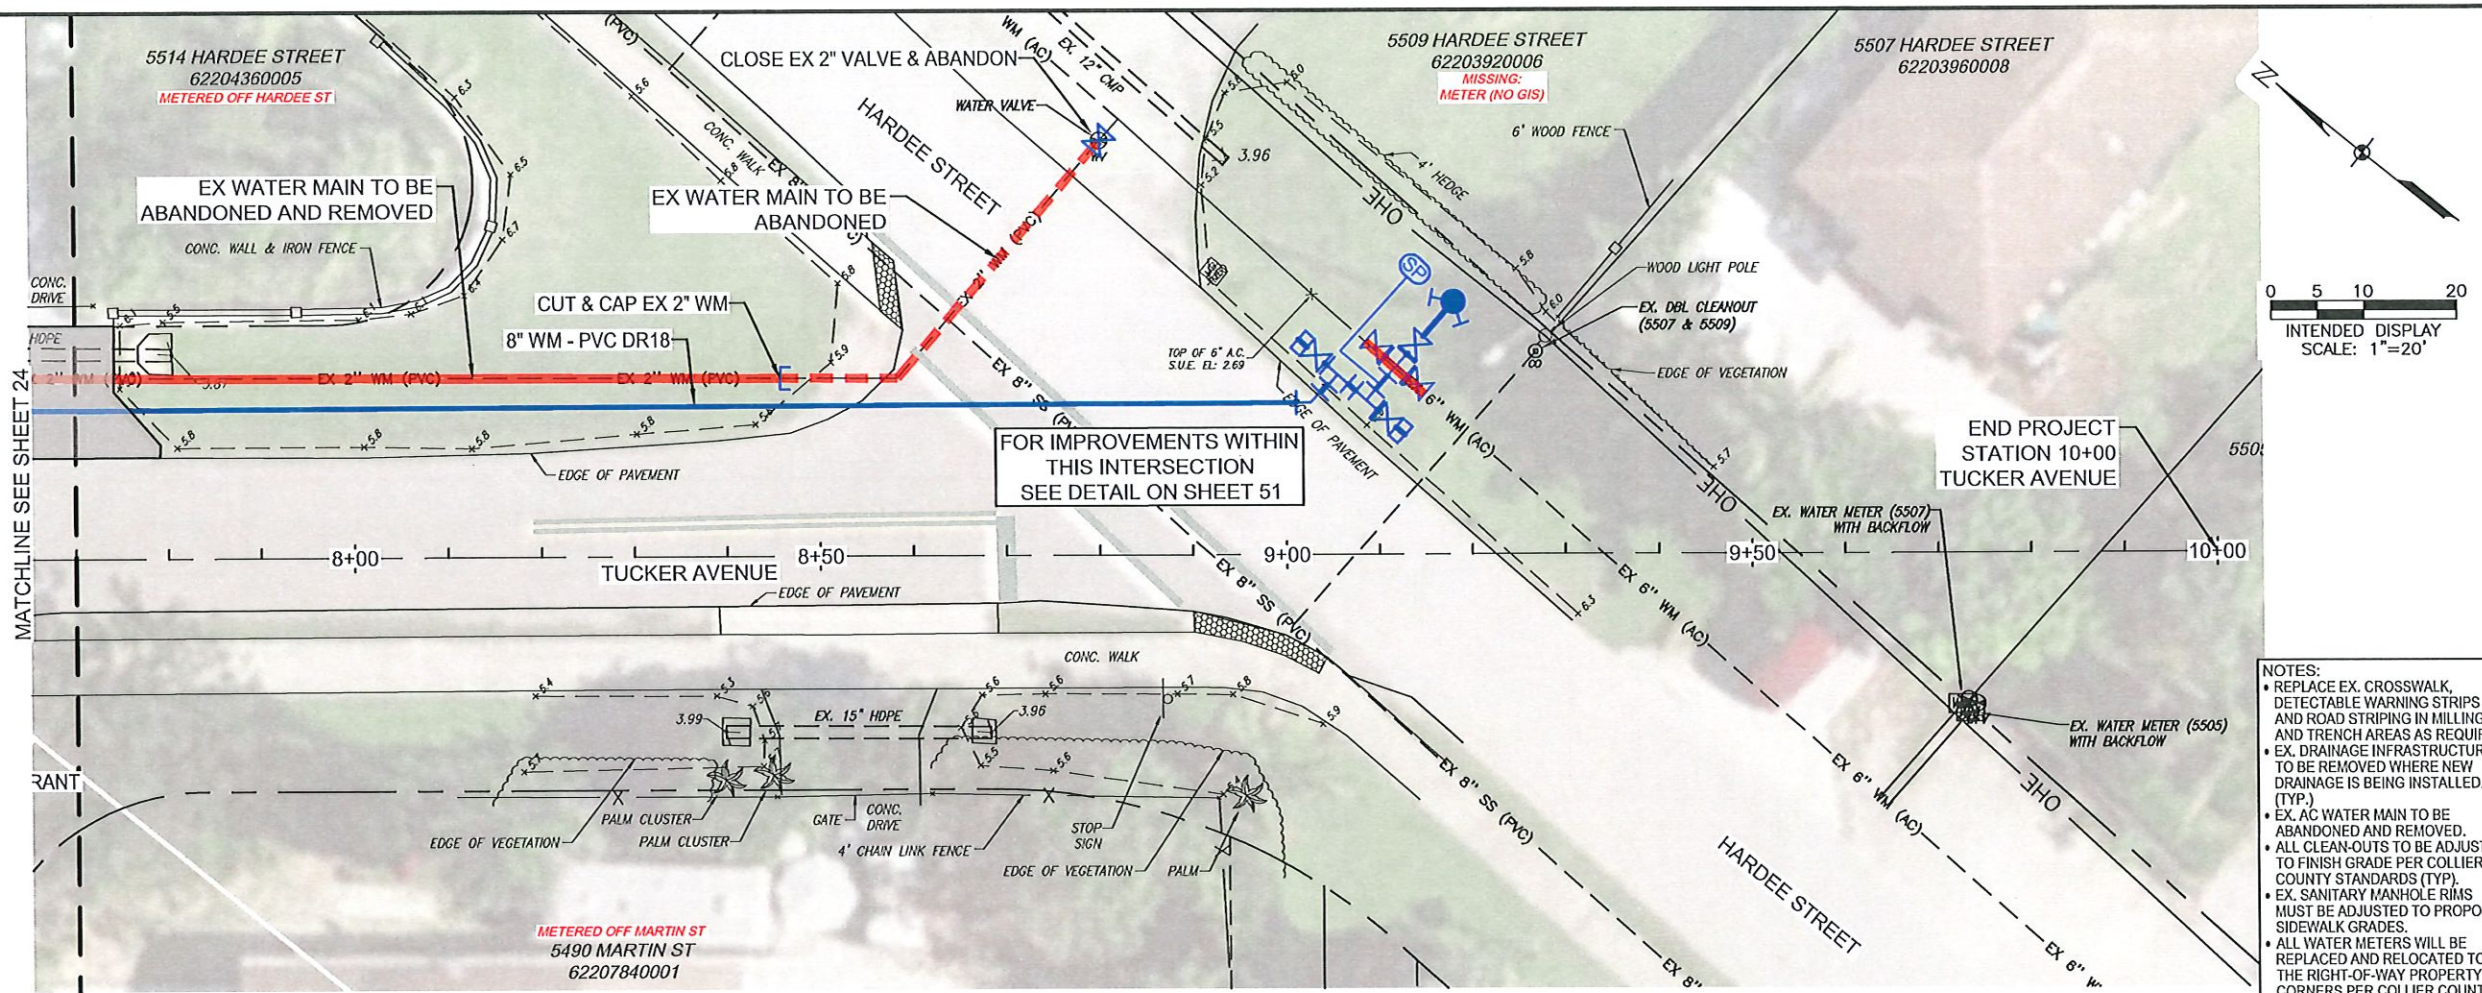

- NOTES:
- REPLACE EX. CROSSWALK, DETECTABLE WARNING STRIPS AND ROAD STRIPING IN MILLING AND TRENCH AREAS AS REQUIRED.
 - EX. DRAINAGE INFRASTRUCTURE TO BE REMOVED WHERE NEW DRAINAGE IS BEING INSTALLED. (TYP.)
 - EX. AC WATER MAIN TO BE ABANDONED AND REMOVED.
 - ALL CLEAN-OUTS TO BE ADJUSTED TO FINISH GRADE PER COLLIER COUNTY STANDARDS (TYP.)
 - EX. SANITARY MANHOLE RIMS MUST BE ADJUSTED TO PROPOSED SIDEWALK GRADES.
 - ALL WATER METERS WILL BE REPLACED AND RELOCATED TO THE RIGHT-OF-WAY PROPERTY CORNERS PER COLLIER COUNTY STANDARDS. ALL NEW WATER METERS AND BOXES TO BE PROVIDED BY COLLIER COUNTY (TYP.)
 - REPRESENTS THE ALTERNATE PORTIONS OF THIS PROJECT. ALL DRIVEWAY, SIDEWALK, AND DRAINAGE ON THE NORTH / LEFT SIDE OF CARLTON WILL BE PART OF AN ALTERNATE PROJECT UNLESS OTHERWISE NOTED.

Tucker Avenue Sta: 7+70 to Sta: 10+00

Hor. Scale: 1" = 20', Vert. Scale: 1" = 2'

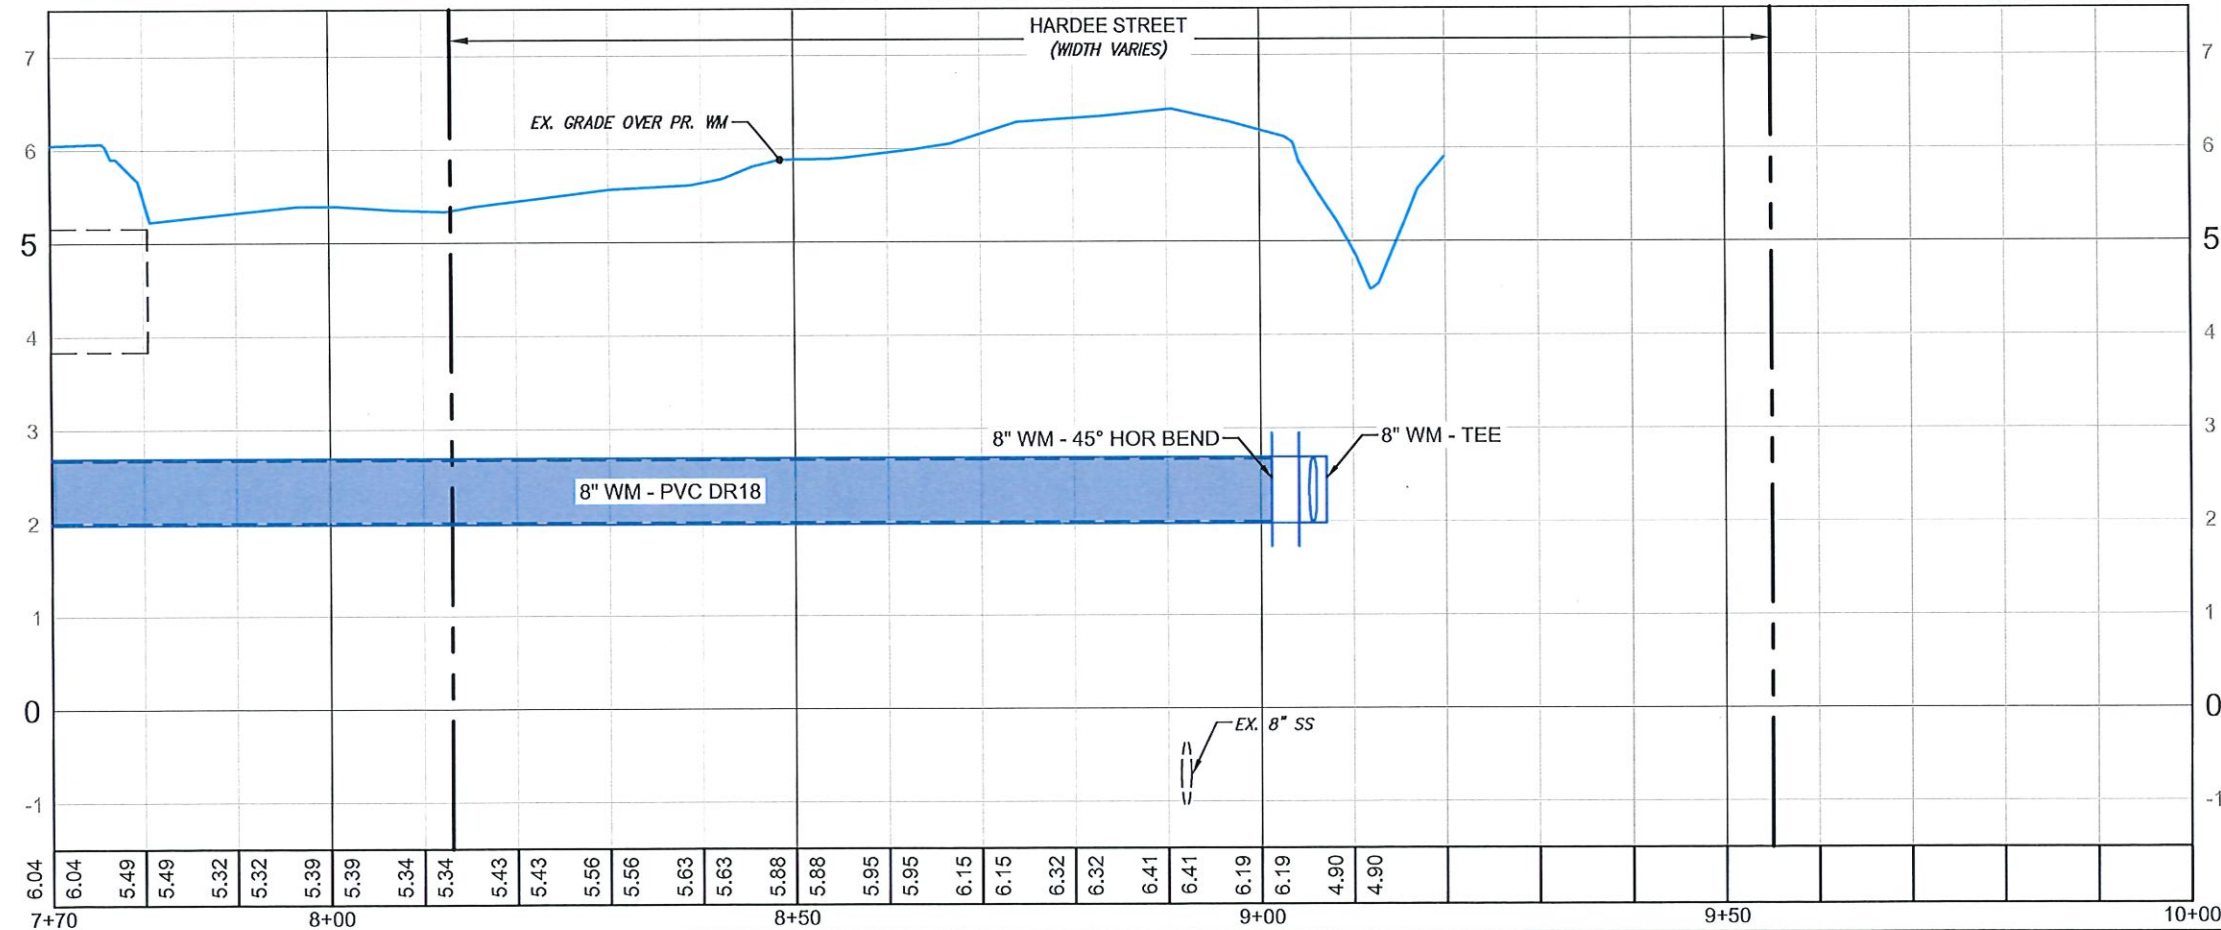

JOHNSON ENGINEERING
JOHNSON ENGINEERING, INC.
2350 STANFORD COURT
NAPLES, FLORIDA 34112
PHONE: (239) 434-0333
E.B. #642 & L.B. #642




Carlton Street Sidewalk
and Utility Improvements
Collier County, Florida

REVISIONS	
NO.	DESCRIPTION



DATE: April 26, 2024
PROJECT NO. 20203067-034
FILE NO. 50-29-26
SCALE: As Shown

 
Construction Plans
Utility Plan & Profile
Tucker Avenue
Sta 7+70 to 10+00



NOTES:

- REPLACE EX. CROSSWALK, DETECTABLE WARNING STRIPS AND ROAD STRIPING IN MILLING AND TRENCH AREAS AS REQUIRED.
- EX. DRAINAGE INFRASTRUCTURE TO BE REMOVED WHERE NEW DRAINAGE IS BEING INSTALLED. (TYP.)
- EX. AC WATER MAIN TO BE ABANDONED AND REMOVED.
- ALL CLEAN-OUTS TO BE ADJUSTED TO FINISH GRADE PER COLLIER COUNTY STANDARDS (TYP).
- EX. SANITARY MANHOLE RIMS MUST BE ADJUSTED TO PROPOSED SIDEWALK GRADES.
- ALL WATER METERS WILL BE REPLACED AND RELOCATED TO THE RIGHT-OF-WAY PROPERTY CORNERS PER COLLIER COUNTY STANDARDS. ALL NEW WATER METERS AND BOXES TO BE PROVIDED BY COLLIER COUNTY (TYP).
- REPRESENTS THE ALTERNATE PORTIONS OF THIS PROJECT. ALL DRIVEWAY, SIDEWALK, AND DRAINAGE ON THE NORTH / LEFT SIDE OF CARLTON WILL BE PART OF AN ALTERNATE PROJECT UNLESS OTHERWISE NOTED.

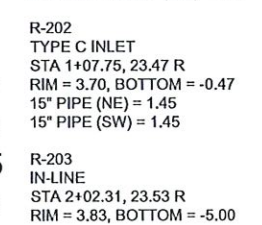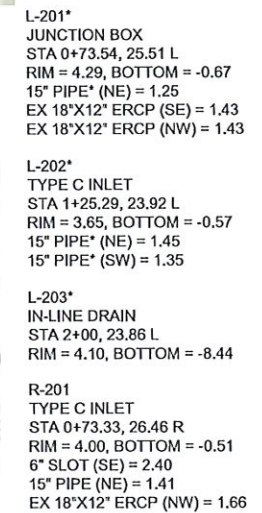

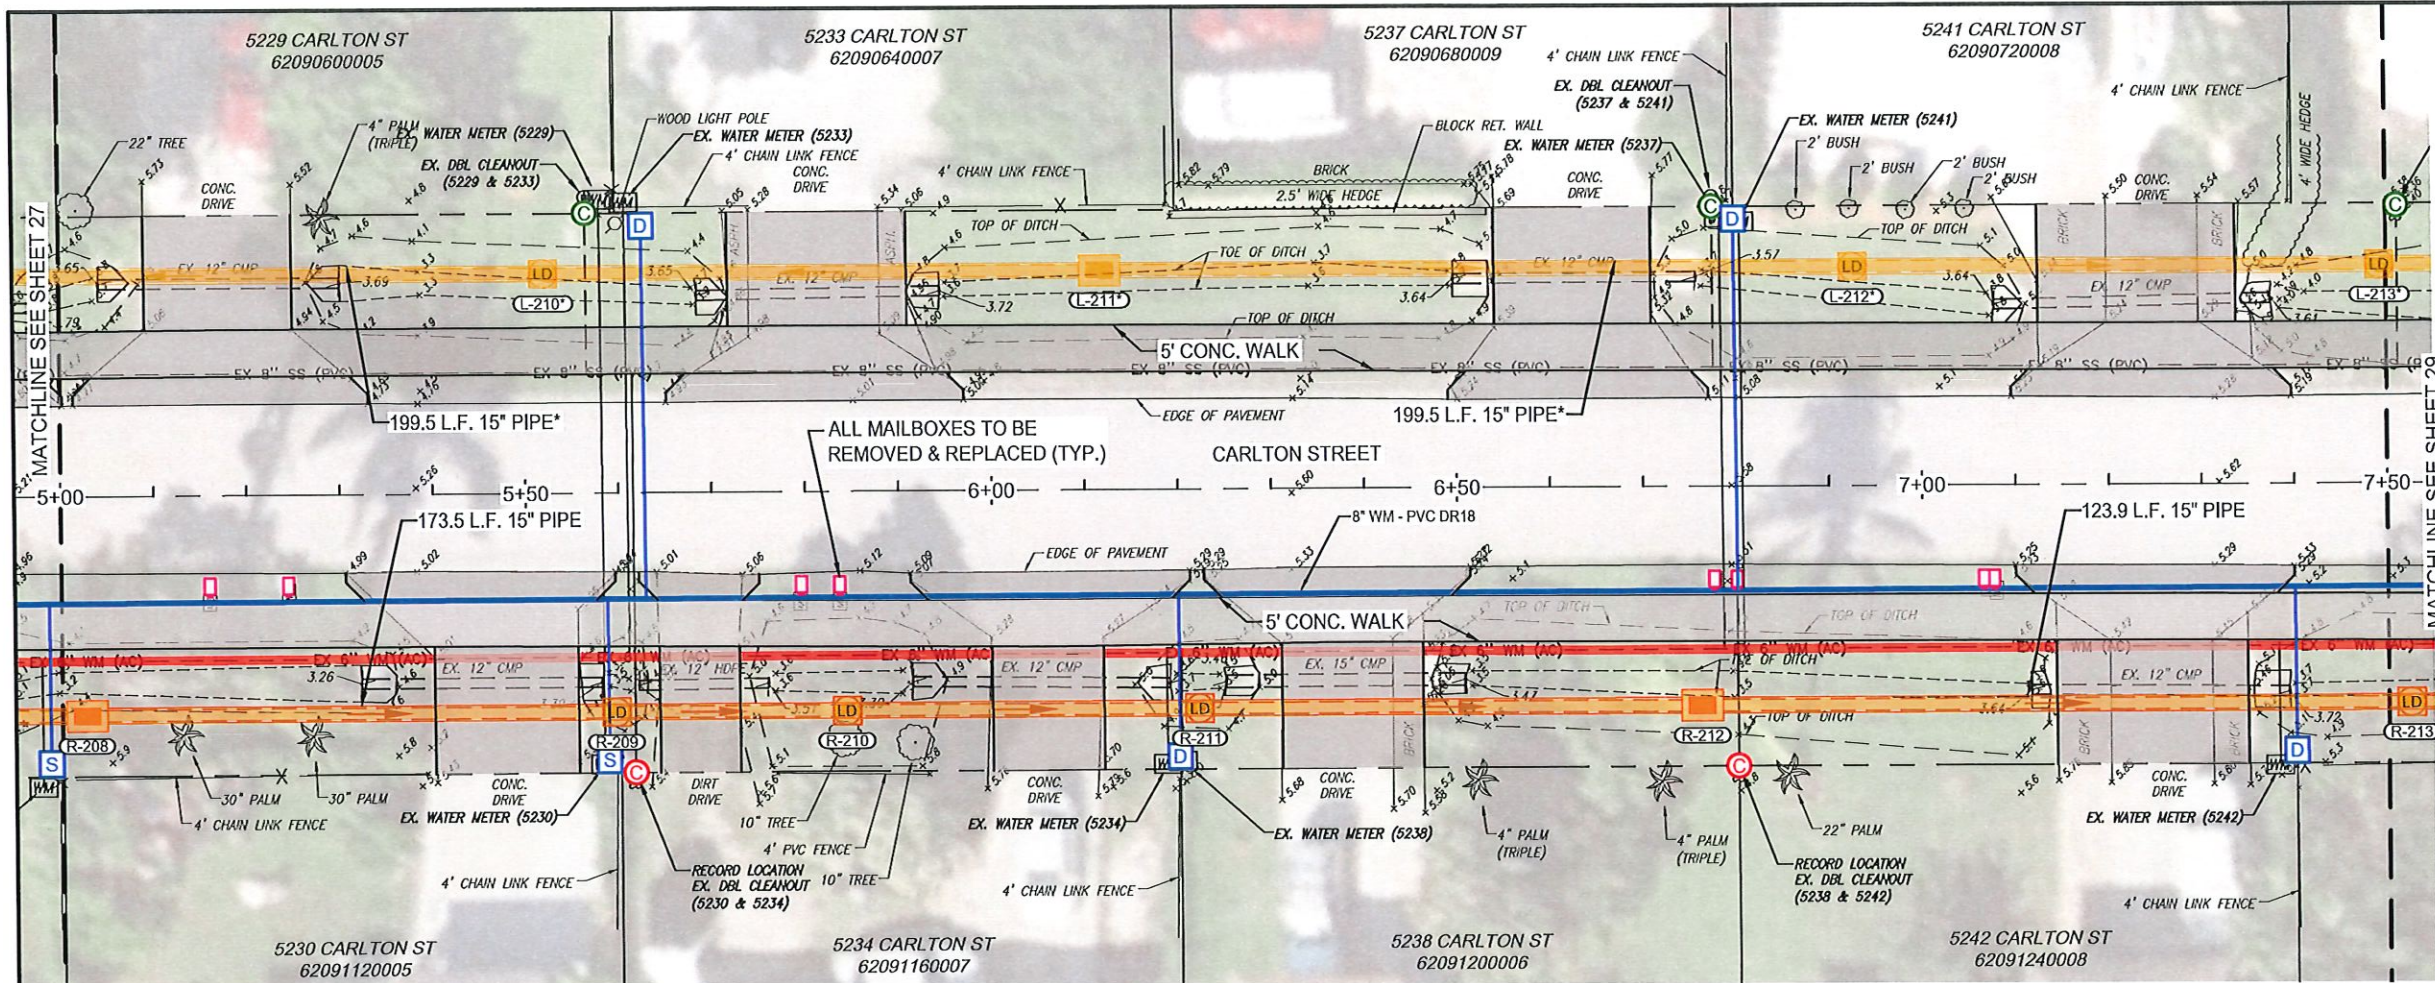


- NOTES:
- REPLACE EX. CROSSWALK, DETECTABLE WARNING STRIPS AND ROAD STRIPING IN MILLING AND TRENCH AREAS AS REQUIRED.
 - EX. DRAINAGE INFRASTRUCTURE TO BE REMOVED WHERE NEW DRAINAGE IS BEING INSTALLED. (TYP.)
 - EX. AC WATER MAIN TO BE ABANDONED AND REMOVED.
 - ALL CLEAN-OUTS TO BE ADJUSTED TO FINISH GRADE PER COLLIER COUNTY STANDARDS (TYP.).
 - EX. SANITARY MANHOLE RIMS MUST BE ADJUSTED TO PROPOSED SIDEWALK GRADES.
 - ALL WATER METERS WILL BE REPLACED AND RELOCATED TO THE RIGHT-OF-WAY PROPERTY CORNERS PER COLLIER COUNTY STANDARDS. ALL NEW WATER METERS AND BOXES TO BE PROVIDED BY COLLIER COUNTY (TYP.).
 - REPRESENTS THE ALTERNATE PORTIONS OF THIS PROJECT. ALL DRIVEWAY, SIDEWALK, AND DRAINAGE ON THE NORTH / LEFT SIDE OF CARLTON WILL BE PART OF AN ALTERNATE PROJECT UNLESS OTHERWISE NOTED.

- L-210*
IN-LINE DRAIN
STA 5+52.17, 23.55 L
RIM = 3.80, BOTTOM = -5.00
- L-211*
TYPE C INLET
STA 6+11.92, 23.52 L
RIM = 4.20, BOTTOM = -0.17
15" PIPE* (SW) = 1.75
15" PIPE* (NE) = 1.75
- L-212*
IN-LINE DRAIN
STA 6+92.79, 23.44 L
RIM = 4.41, BOTTOM = -5.00
- L-213*
IN-LINE DRAIN
STA 7+49.41, 23.40 L
RIM = 4.50, BOTTOM = -5.00
- R-208
TYPE C INLET
STA 5+02.59, 23.50 R
RIM = 3.88, BOTTOM = -0.17
15" PIPE (SW) = 1.75
15" PIPE (NE) = 1.75
- R-209
IN-LINE
STA 5+59.55, 23.50 R
RIM = 4.54, BOTTOM = -5.00
- R-210
IN-LINE
STA 5+84.24, 23.50 R
RIM = 4.63, BOTTOM = -5.00
- R-211
IN-LINE
STA 6+22.12, 23.50 R
RIM = 4.20, BOTTOM = -5.00
- R-212
TYPE C INLET
STA 6+76.13, 23.50 R
RIM = 4.20, BOTTOM = -0.27
15" PIPE (SW) = 1.65
15" PIPE (NE) = 1.65


Carlton Street Sta: 5+00 to Sta: 7+50 (LEFT SIDE)



Hor. Scale: 1" = 20', Vert. Scale: 1" = 5'

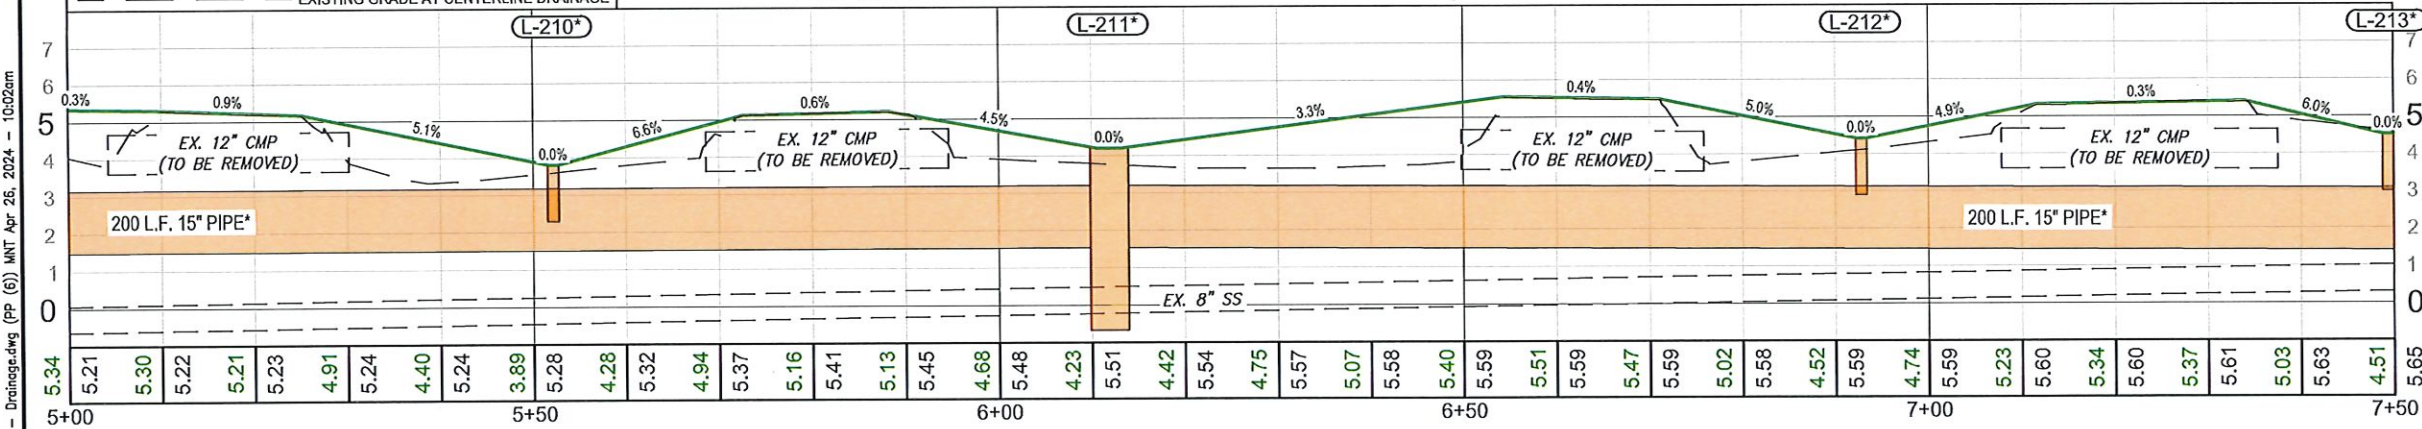

Carlton Street Sta: 5+00 to Sta: 7+50 (RIGHT SIDE)


Hor. Scale: 1" = 20', Vert. Scale: 1" = 5'

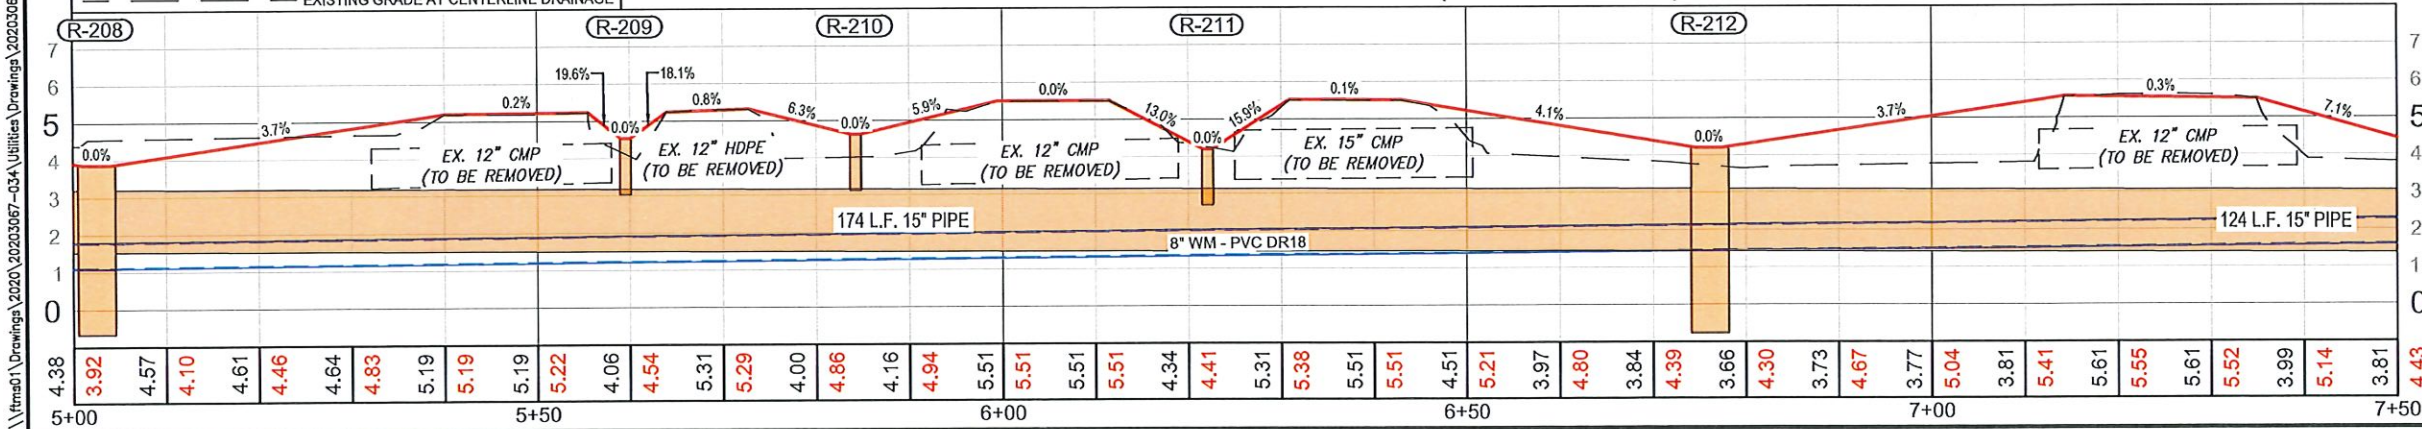

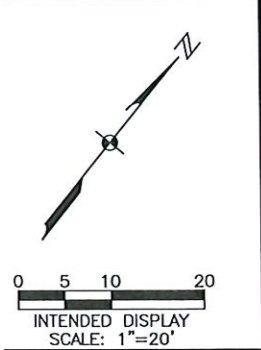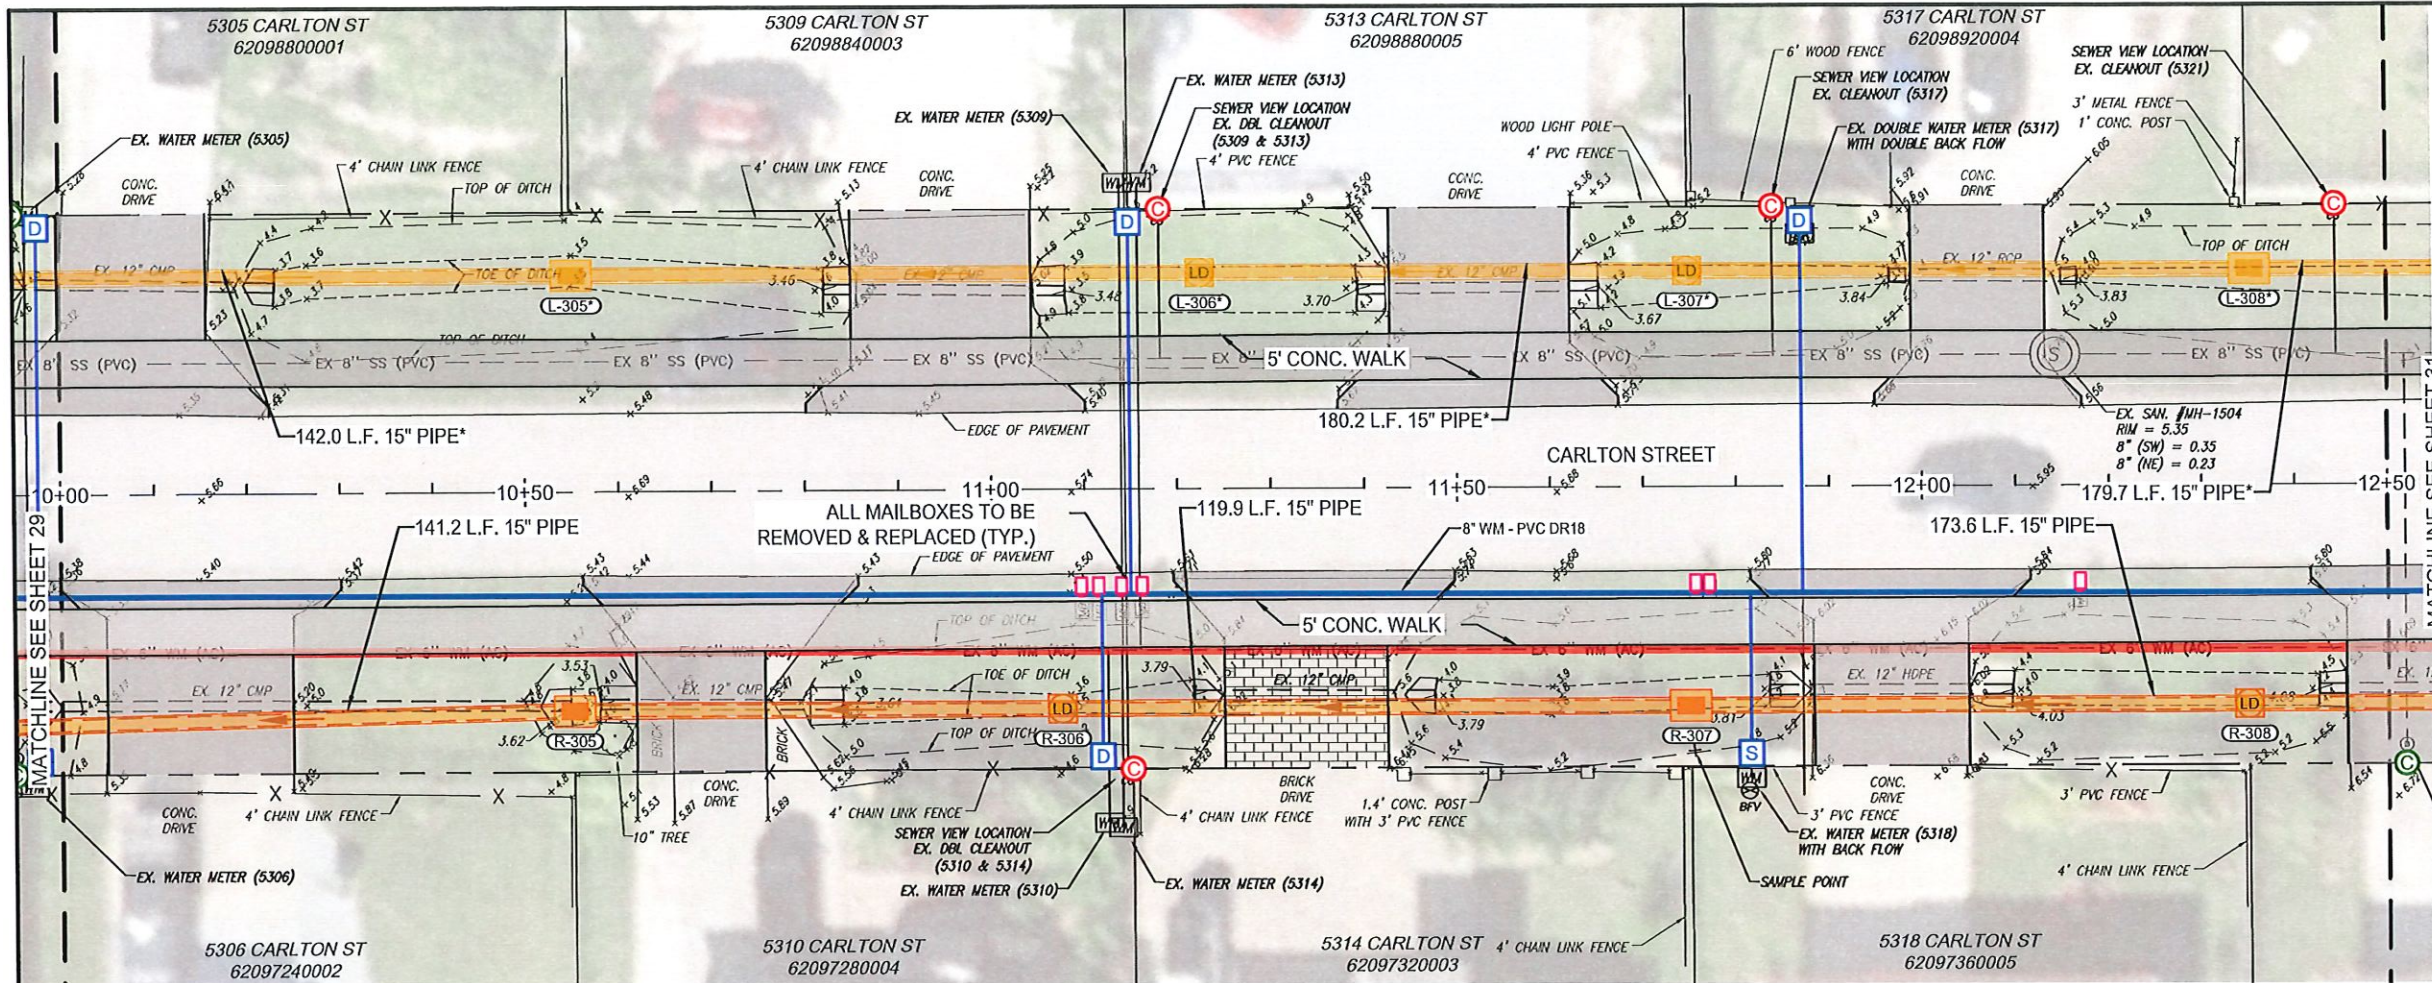


- NOTES:
- REPLACE EX. CROSSWALK, DETECTABLE WARNING STRIPS AND ROAD STRIPING IN MILLING AND TRENCH AREAS AS REQUIRED.
 - EX. DRAINAGE INFRASTRUCTURE TO BE REMOVED WHERE NEW DRAINAGE IS BEING INSTALLED. (TYP.)
 - EX. AC WATER MAIN TO BE ABANDONED AND REMOVED.
 - ALL CLEAN-OUTS TO BE ADJUSTED TO FINISH GRADE PER COLLIER COUNTY STANDARDS (TYP.).
 - EX. SANITARY MANHOLE RIMS MUST BE ADJUSTED TO PROPOSED SIDEWALK GRADES.
 - ALL WATER METERS WILL BE REPLACED AND RELOCATED TO THE RIGHT-OF-WAY PROPERTY CORNERS PER COLLIER COUNTY STANDARDS. ALL NEW WATER METERS AND BOXES TO BE PROVIDED BY COLLIER COUNTY (TYP.).
 - REPRESENTS THE ALTERNATE PORTIONS OF THIS PROJECT. ALL DRIVEWAY, SIDEWALK, AND DRAINAGE ON THE NORTH / LEFT SIDE OF CARLTON WILL BE PART OF AN ALTERNATE PROJECT UNLESS OTHERWISE NOTED.

Carlton Street Sta: 10+00 to Sta: 12+50 (LEFT SIDE)

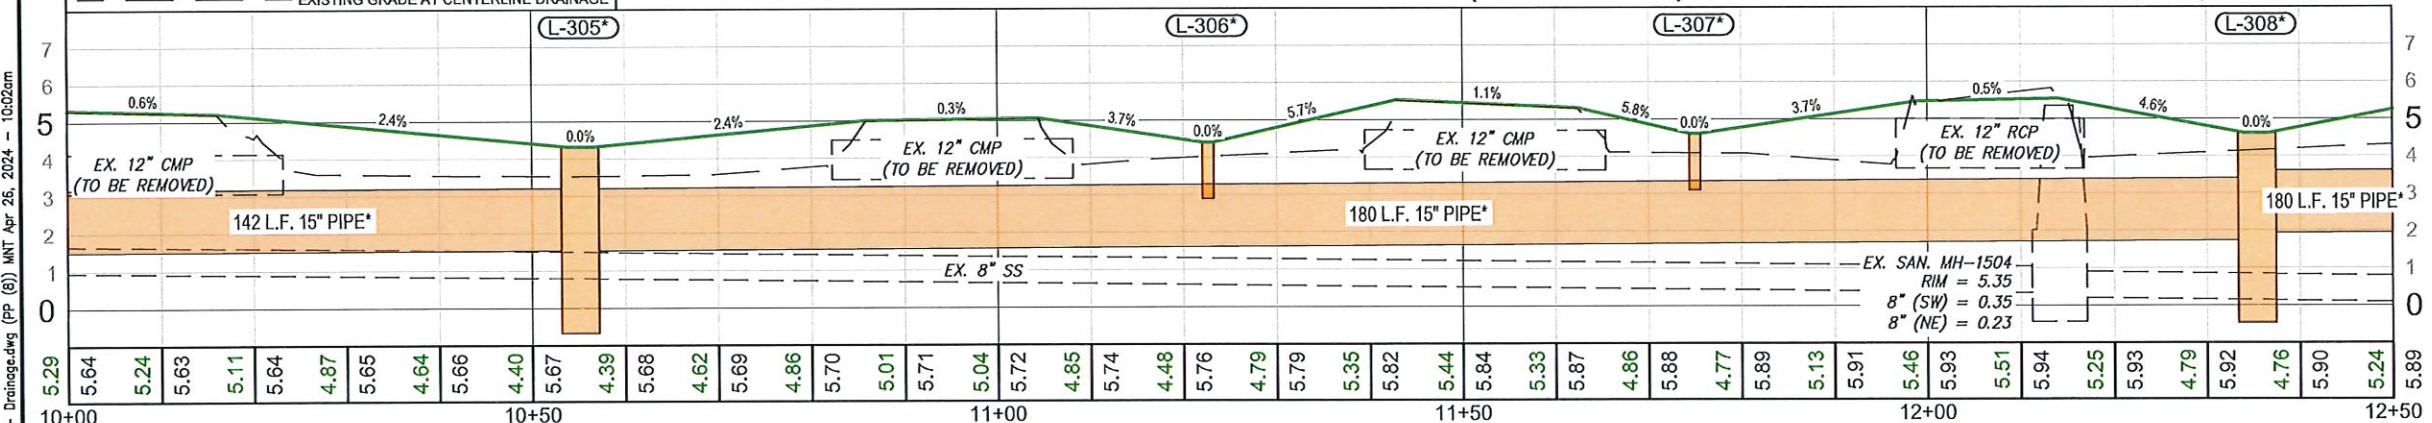

- L-305*
TYPE C INLET
STA 10+55.18, 23.20 L
RIM = 4.31, BOTTOM = -0.17
15" PIPE* (NE) = 1.75
15" PIPE* (SW) = 1.75
- L-306*
IN-LINE DRAIN
STA 11+22.67, 23.16 L
RIM = 4.40, BOTTOM = -5.00
- L-307*
IN-LINE DRAIN
STA 11+75, 23.13 L
RIM = 4.60, BOTTOM = -5.00
- L-308*
TYPE C INLET
STA 12+35.38, 23.09 L
RIM = 4.60, BOTTOM = 0.03
15" PIPE* (NE) = 2.15
15" PIPE* (SW) = 1.95
- R-305
TYPE C INLET
STA 10+55.07, 23.50 R
RIM = 4.58, BOTTOM = 0.50
15" PIPE (NE) = 2.25
15" PIPE (SW) = 2.25
- R-306
IN-LINE
STA 11+07.43, 23.50 R
RIM = 4.50, BOTTOM = -5.00
- R-307
TYPE C INLET
STA 11+74.95, 23.50 R
RIM = 4.83, BOTTOM = 0.60
15" PIPE (NE) = 2.55
15" PIPE (SW) = 2.35
- R-308
IN-LINE
STA 12+34.97, 23.50 R
RIM = 4.85, BOTTOM = -5.00

Carlton Street Sta: 10+00 to Sta: 12+50 (RIGHT SIDE)

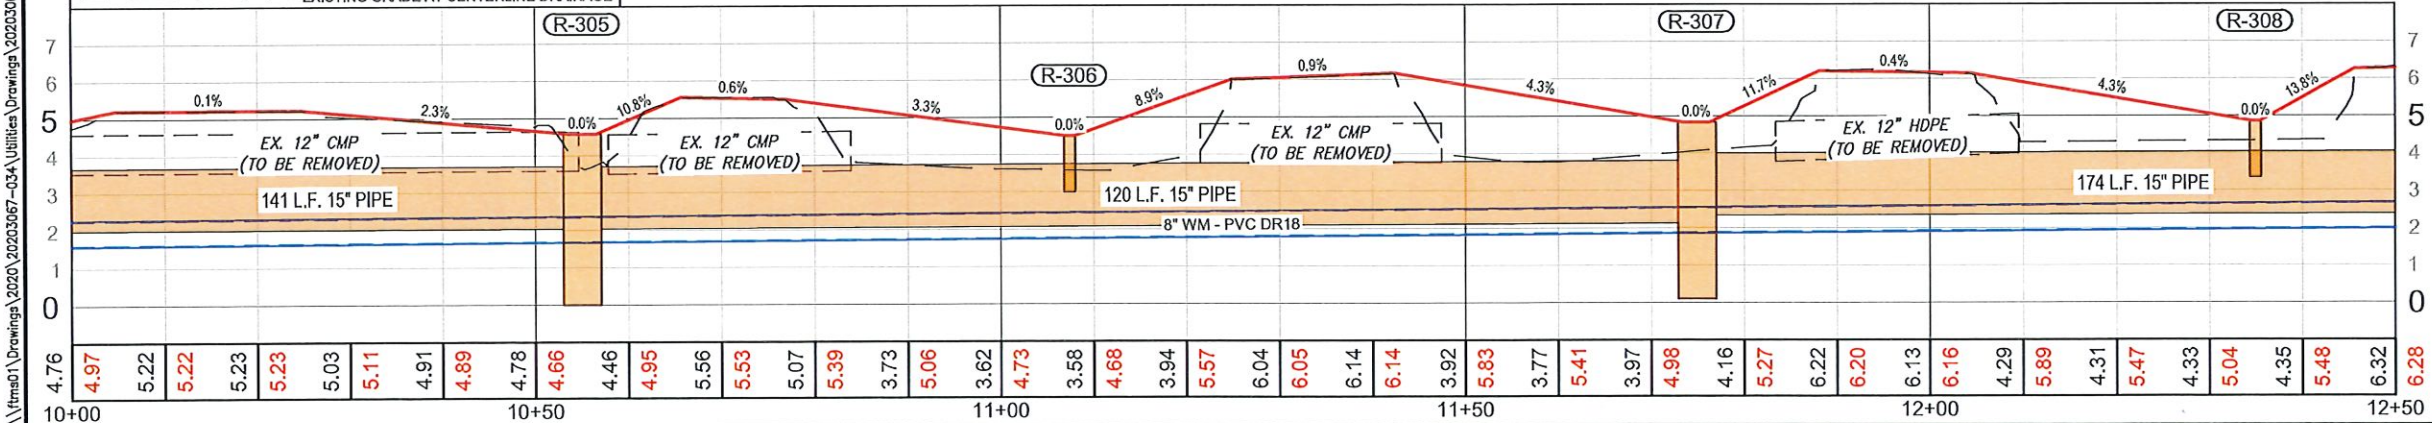

- R-305
TYPE C INLET
STA 10+55.07, 23.50 R
RIM = 4.58, BOTTOM = 0.50
15" PIPE (NE) = 2.25
15" PIPE (SW) = 2.25
- R-306
IN-LINE
STA 11+07.43, 23.50 R
RIM = 4.50, BOTTOM = -5.00
- R-307
TYPE C INLET
STA 11+74.95, 23.50 R
RIM = 4.83, BOTTOM = 0.60
15" PIPE (NE) = 2.55
15" PIPE (SW) = 2.35
- R-308
IN-LINE
STA 12+34.97, 23.50 R
RIM = 4.85, BOTTOM = -5.00




Carlton Street Sidewalk
and Utility Improvements
Collier County, Florida

REVISIONS	
NO.	DESCRIPTION

DATE: April 26, 2024
PROJECT NO. 20203067-034
FILE NO. 50-29-26
SCALE: As Shown


Construction Plans
Drainage Plan &
Profile Carlton Street
Sta 10+00 to 12+50

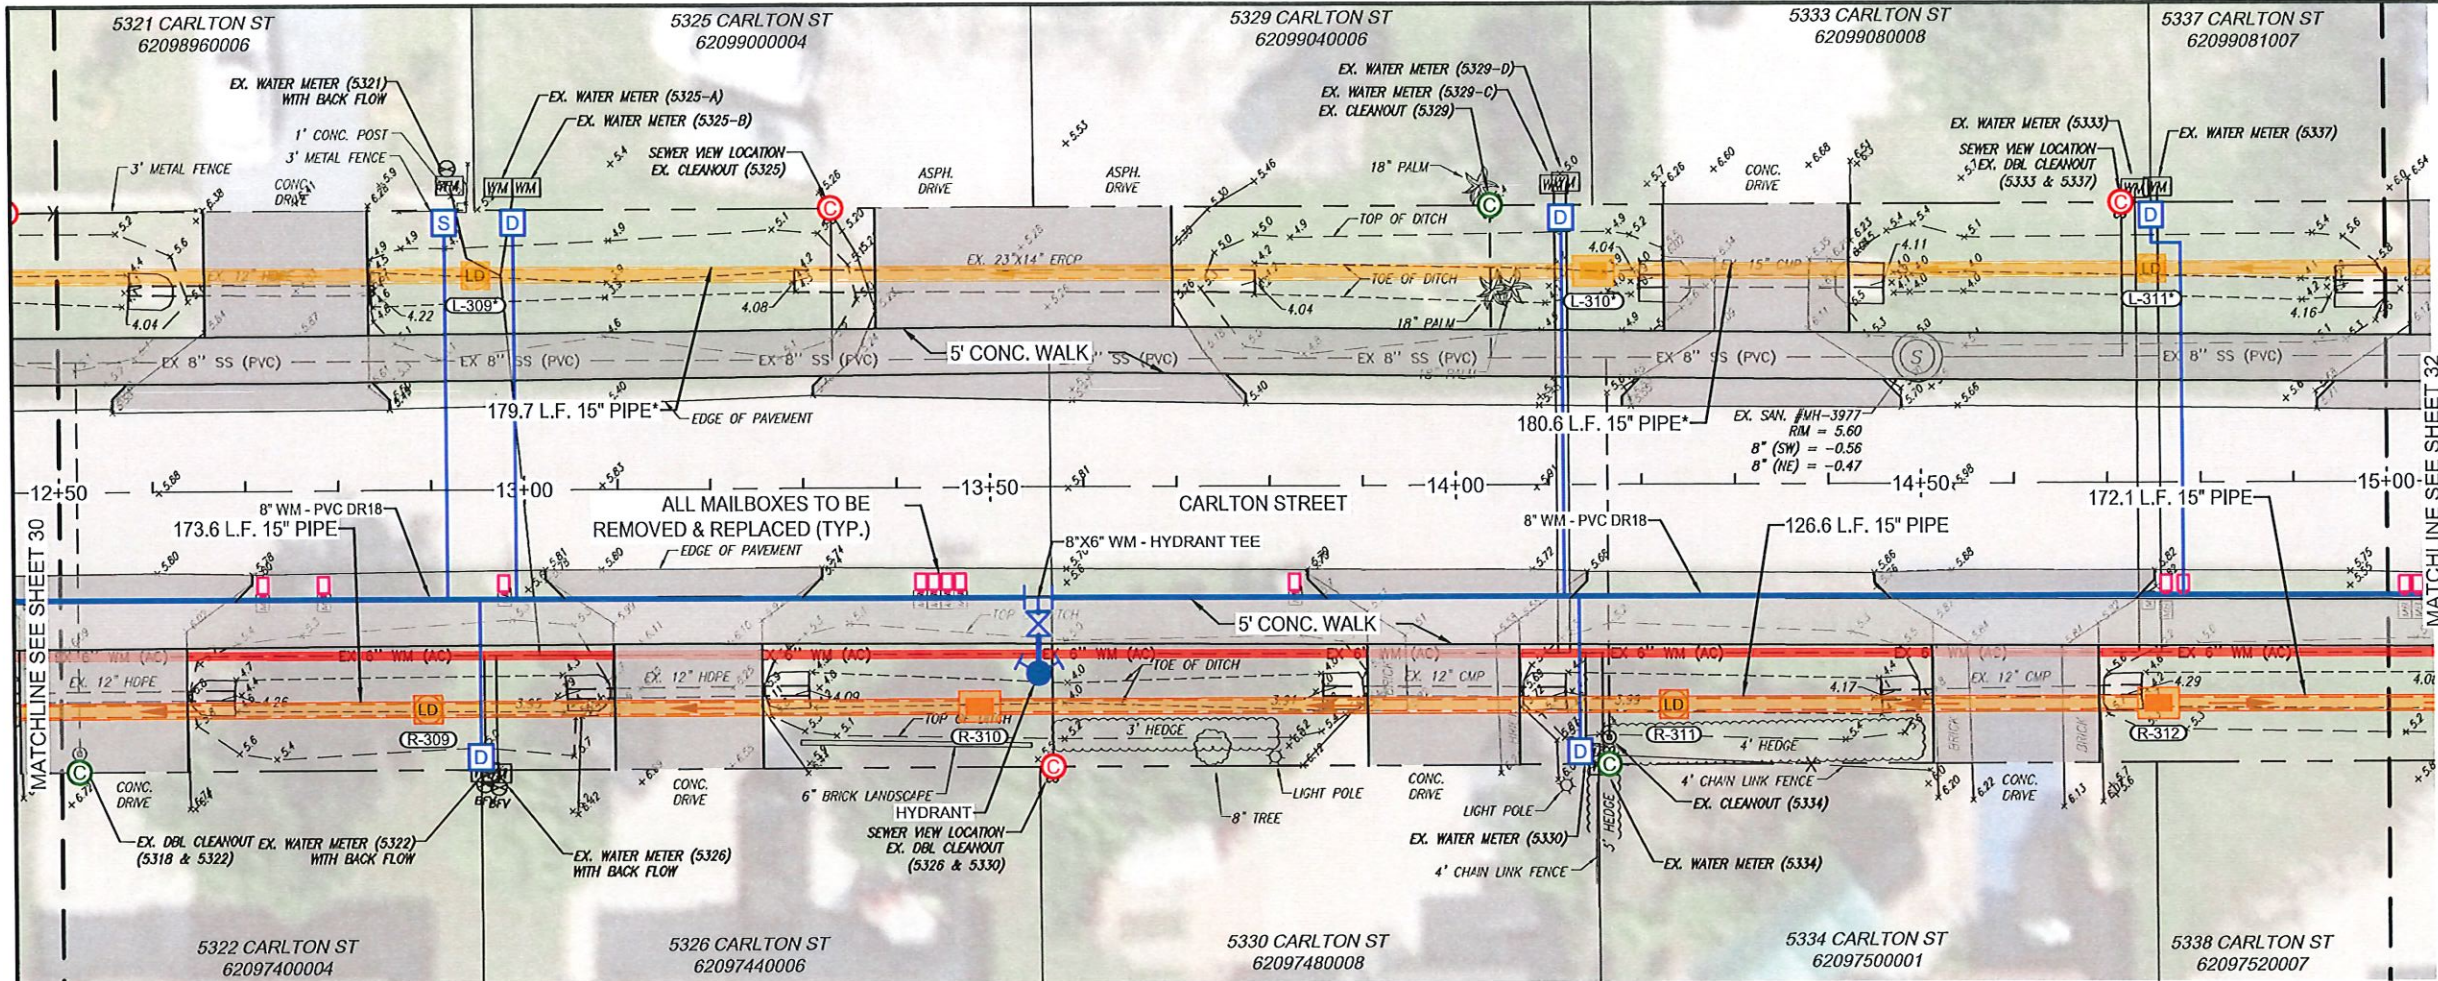


- NOTES:
- REPLACE EX. CROSSWALK, DETECTABLE WARNING STRIPS AND ROAD STRIPING IN MILLING AND TRENCH AREAS AS REQUIRED.
 - EX. DRAINAGE INFRASTRUCTURE TO BE REMOVED WHERE NEW DRAINAGE IS BEING INSTALLED. (TYP.)
 - EX. AC WATER MAIN TO BE ABANDONED AND REMOVED.
 - ALL CLEAN-OUTS TO BE ADJUSTED TO FINISH GRADE PER COLLIER COUNTY STANDARDS (TYP.).
 - EX. SANITARY MANHOLE RIMS MUST BE ADJUSTED TO PROPOSED SIDEWALK GRADES.
 - ALL WATER METERS WILL BE REPLACED AND RELOCATED TO THE RIGHT-OF-WAY PROPERTY CORNERS PER COLLIER COUNTY STANDARDS. ALL NEW WATER METERS AND BOXES TO BE PROVIDED BY COLLIER COUNTY (TYP.).
 - REPRESENTS THE ALTERNATE PORTIONS OF THIS PROJECT. ALL DRIVEWAY, SIDEWALK, AND DRAINAGE ON THE NORTH/LEFT SIDE OF CARLTON WILL BE PART OF AN ALTERNATE PROJECT UNLESS OTHERWISE NOTED.

- L-309*
IN-LINE DRAIN
STA 12+95, 23.02 L
RIM = 4.45, BOTTOM = -5.00
- L-310*
TYPE C INLET
STA 14+15.05, 22.86 L
RIM = 4.70, BOTTOM = 0.33
15" PIPE* (NE) = 2.25
15" PIPE* (SW) = 2.25
- L-311*
IN-LINE DRAIN
STA 14+75, 22.86 L
RIM = 4.65, BOTTOM = -5.00
- R-309
IN-LINE
STA 12+89.37, 23.50 R
RIM = 4.70, BOTTOM = -5.00
- R-310
TYPE C INLET
STA 13+48.58, 23.50 R
RIM = 5.00, BOTTOM = 0.73
15" PIPE (NE) = 2.65
15" PIPE (SW) = 2.65
- R-311
IN-LINE
STA 14+23.15, 23.61 R
RIM = 4.76, BOTTOM = -5.00
- R-312
TYPE C INLET
STA 14+75.22, 23.70 R
RIM = 4.98, BOTTOM = 0.83
15" PIPE (SW) = 2.75
15" PIPE (NE) = 2.75

Carlton Street Sta: 12+50 to Sta: 15+00 (LEFT SIDE)

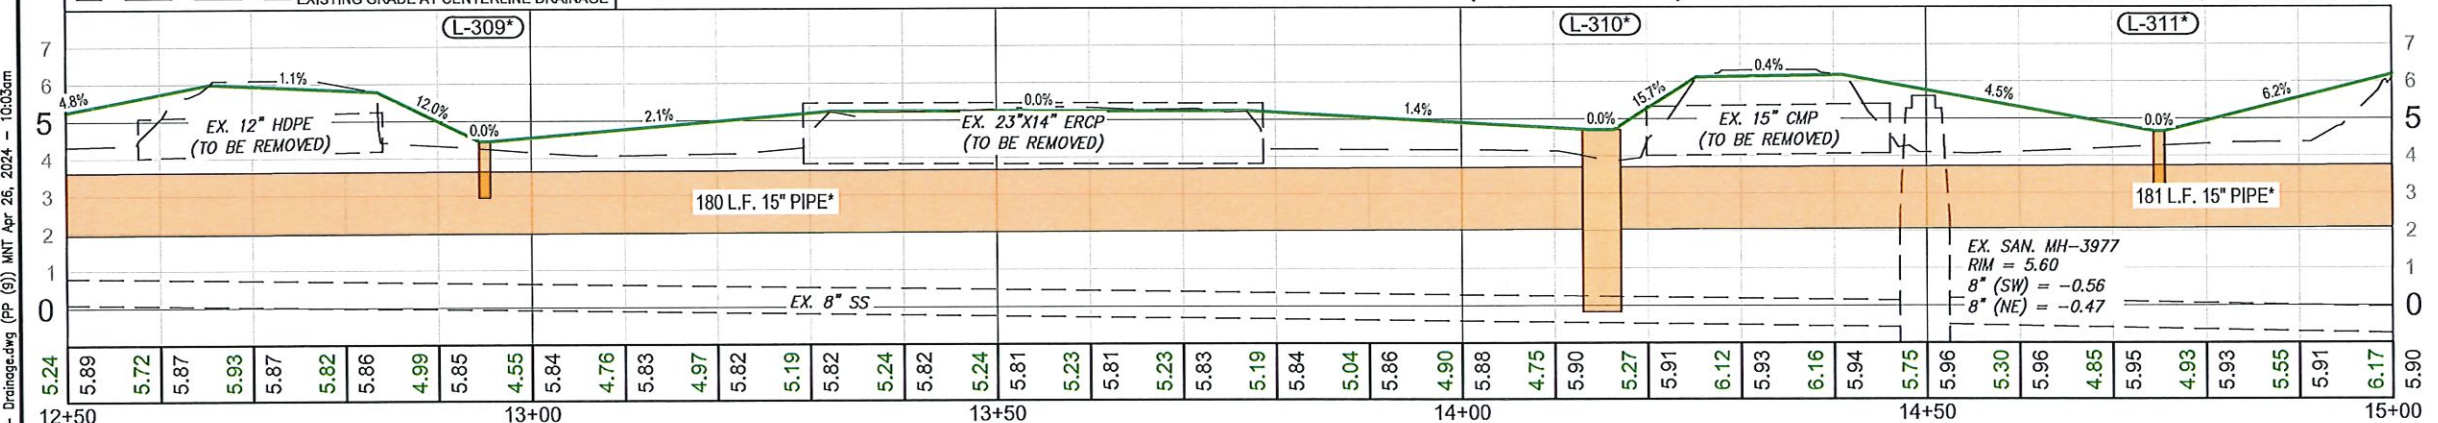

Carlton Street Sta: 12+50 to Sta: 15+00 (RIGHT SIDE)

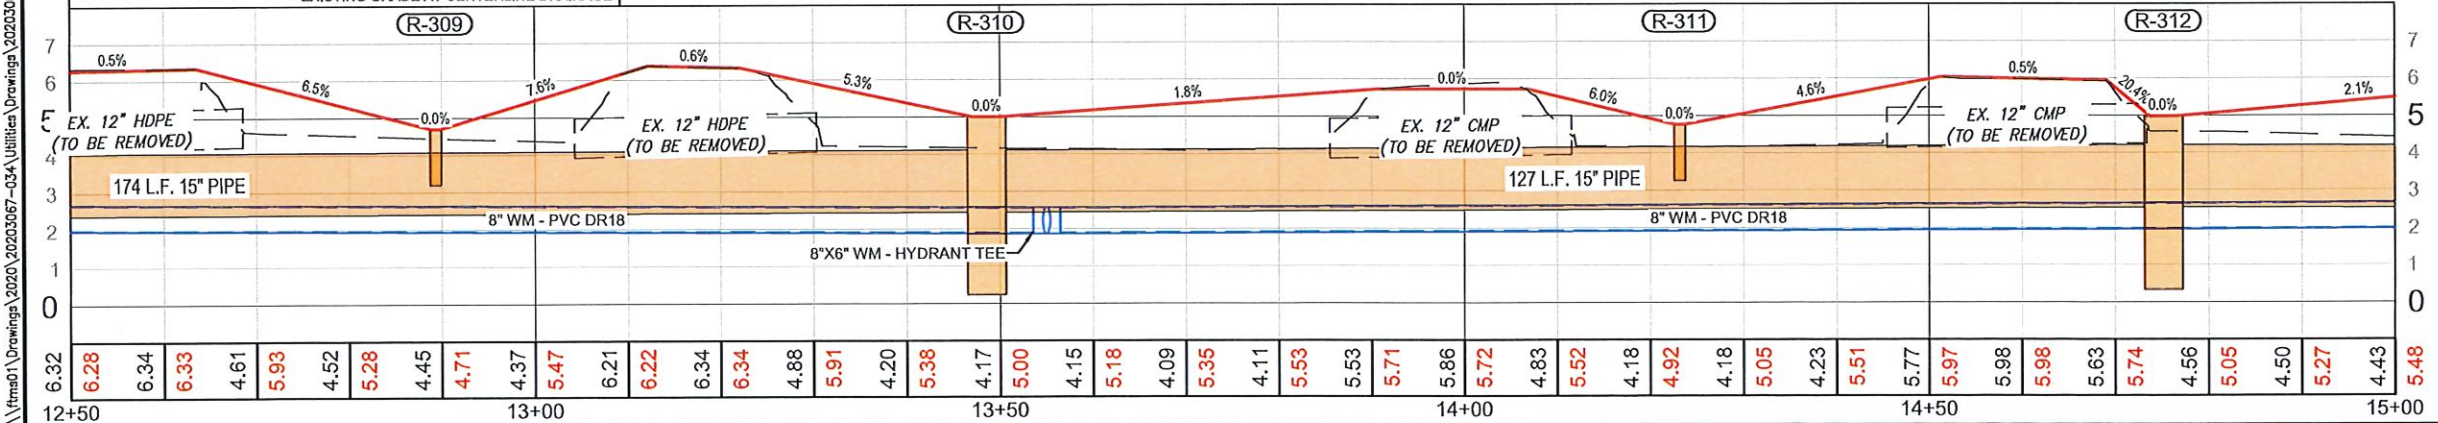


Carlton Street Sidewalk
and Utility Improvements
Collier County, Florida

REVISIONS	
NO.	DESCRIPTION

DATE: April 26, 2024
PROJECT NO. 20203067-034
FILE NO. 50-29-26
SCALE: As Shown

Construction Plans
Drainage Plan &
Profile Carlton Street
Sta 12+50 to 15+00

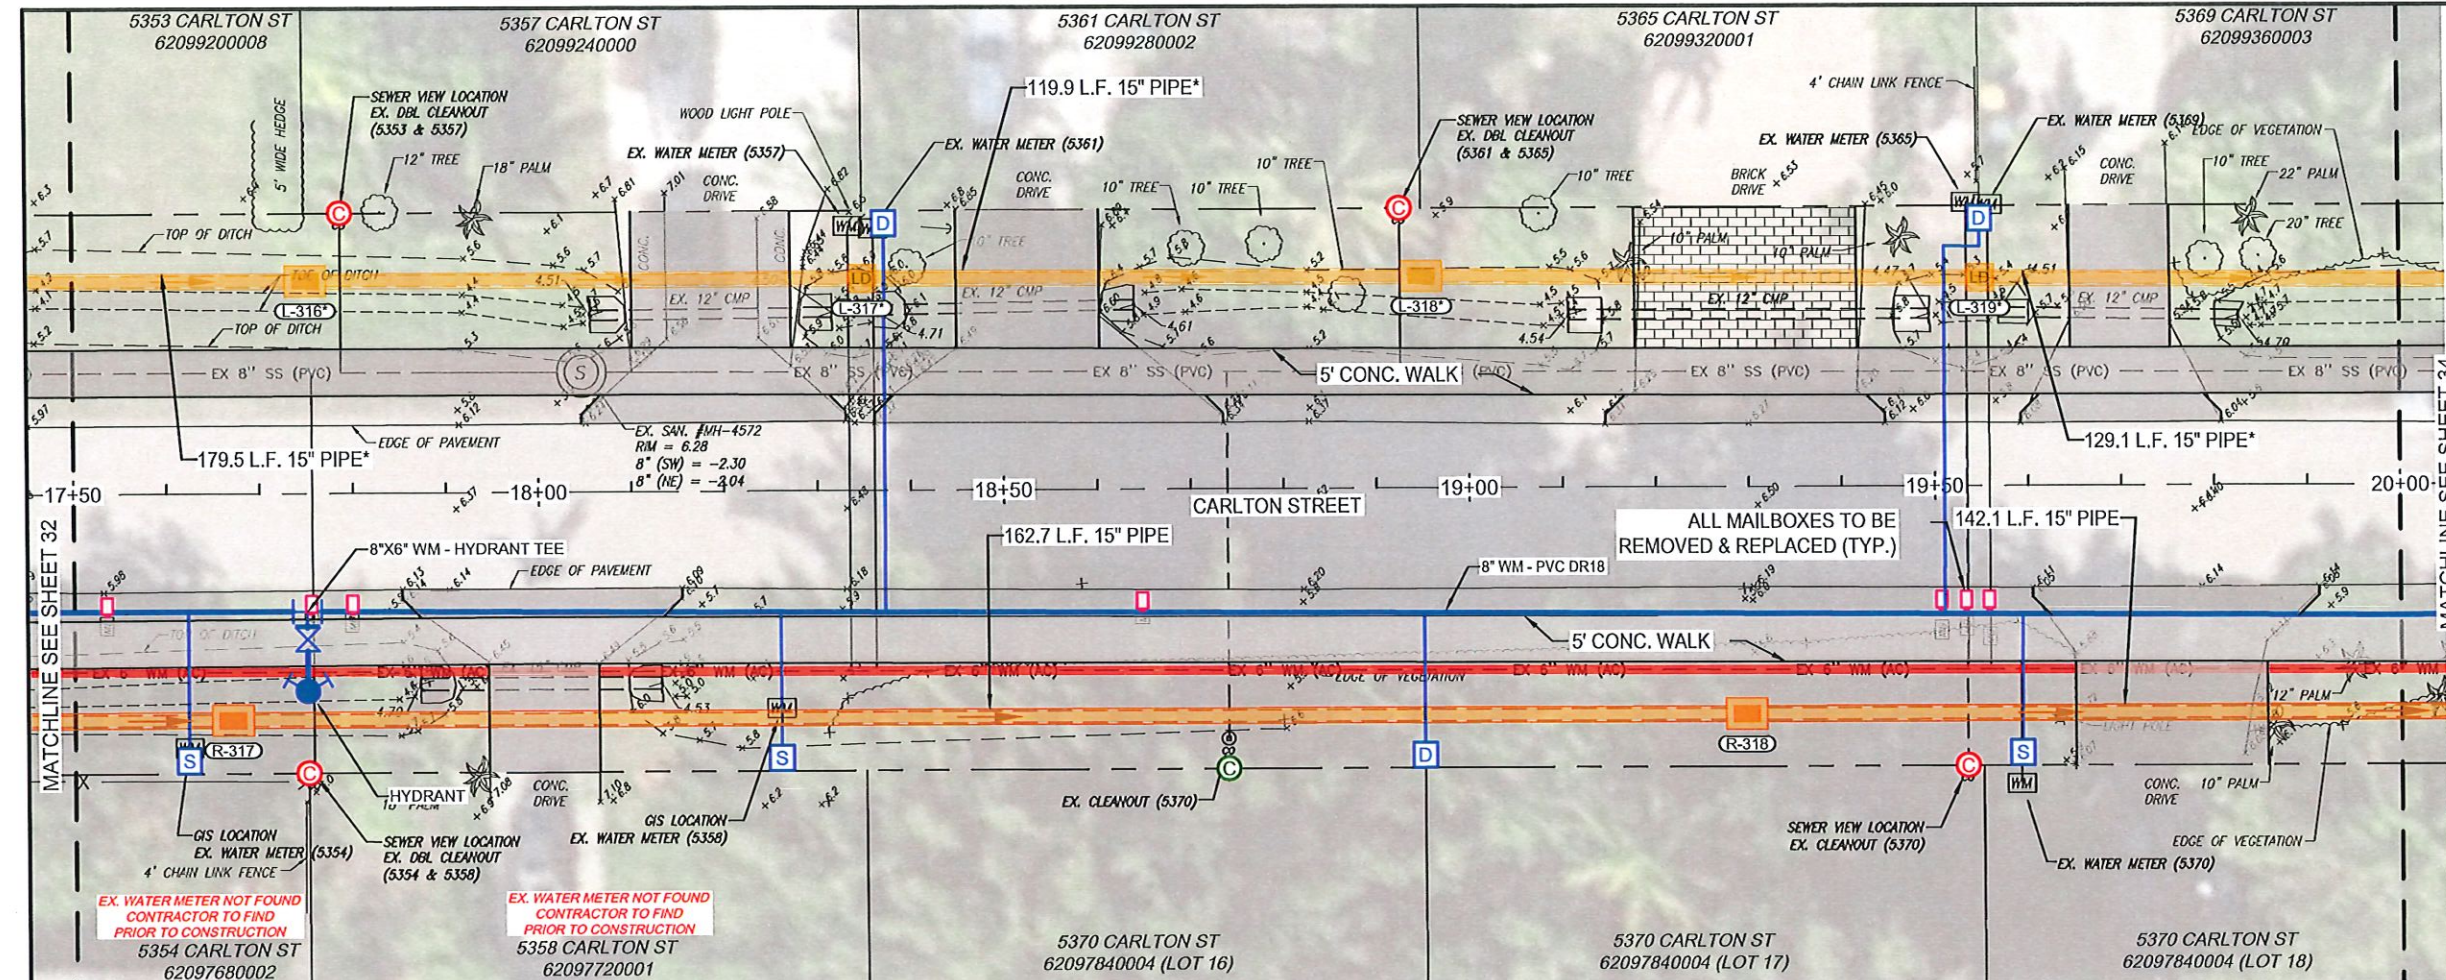

NOTES:

- REPLACE EX. CROSSWALK, DETECTABLE WARNING STRIPS AND ROAD STRIPING IN MILLING AND TRENCH AREAS AS REQUIRED.
- EX. DRAINAGE INFRASTRUCTURE TO BE REMOVED WHERE NEW DRAINAGE IS BEING INSTALLED. (TYP.)
- EX. AC WATER MAIN TO BE ABANDONED AND REMOVED.
- ALL CLEAN-OUTS TO BE ADJUSTED TO FINISH GRADE PER COLLIER COUNTY STANDARDS (TYP.).
- EX. SANITARY MANHOLE RIMS MUST BE ADJUSTED TO PROPOSED SIDEWALK GRADES.
- ALL WATER METERS WILL BE REPLACED AND RELOCATED TO THE RIGHT-OF-WAY PROPERTY CORNERS PER COLLIER COUNTY STANDARDS. ALL NEW WATER METERS AND BOXES TO BE PROVIDED BY COLLIER COUNTY (TYP.).
- * REPRESENTS THE ALTERNATE PORTIONS OF THIS PROJECT. ALL DRIVEWAY, SIDEWALK, AND DRAINAGE ON THE NORTH/LEFT SIDE OF CARLTON STREET WILL BE PART OF AN ALTERNATE PROJECT UNLESS OTHERWISE NOTED.

L-316*
TYPE C INLET
STA 17+75.13, 22.76 L
RIM = 5.26, BOTTOM = 0.13
15" PIPE* (SW) = 2.15
15" PIPE* (NE) = 2.05

L-317*
IN-LINE DRAIN
STA 18+35, 22.73 L
RIM = 5.53, BOTTOM = -5.00

L-318*
TYPE C INLET
STA 18+95.03, 22.69 L
RIM = 5.47, BOTTOM = 0.03
15" PIPE* (SW) = 1.95
15" PIPE* (NE) = 1.95

L-319*
IN-LINE DRAIN
STA 19+55, 22.26 L
RIM = 5.08, BOTTOM = -5.00


L-320*
TYPE C INLET
STA 20+24.14, 21.76 L
RIM = 5.10, BOTTOM = -0.12
15" PIPE* (SW) = 1.85
15" PIPE* (NE) = 1.85

R-317
TYPE C INLET
STA 17+66.90, 24.29 R
RIM = 5.16, BOTTOM = 0.69
15" PIPE (SW) = 2.61
15" PIPE (NE) = 2.61

R-318
TYPE C INLET
STA 19+29.57, 24.37 R
RIM = 5.40, BOTTOM = 0.63
15" PIPE (SW) = 2.55
15" PIPE (NE) = 2.55


Carlton Street Sta: 17+50 to Sta: 20+00 (LEFT SIDE)

Hor. Scale: 1" = 20', Vert. Scale: 1" = 5'

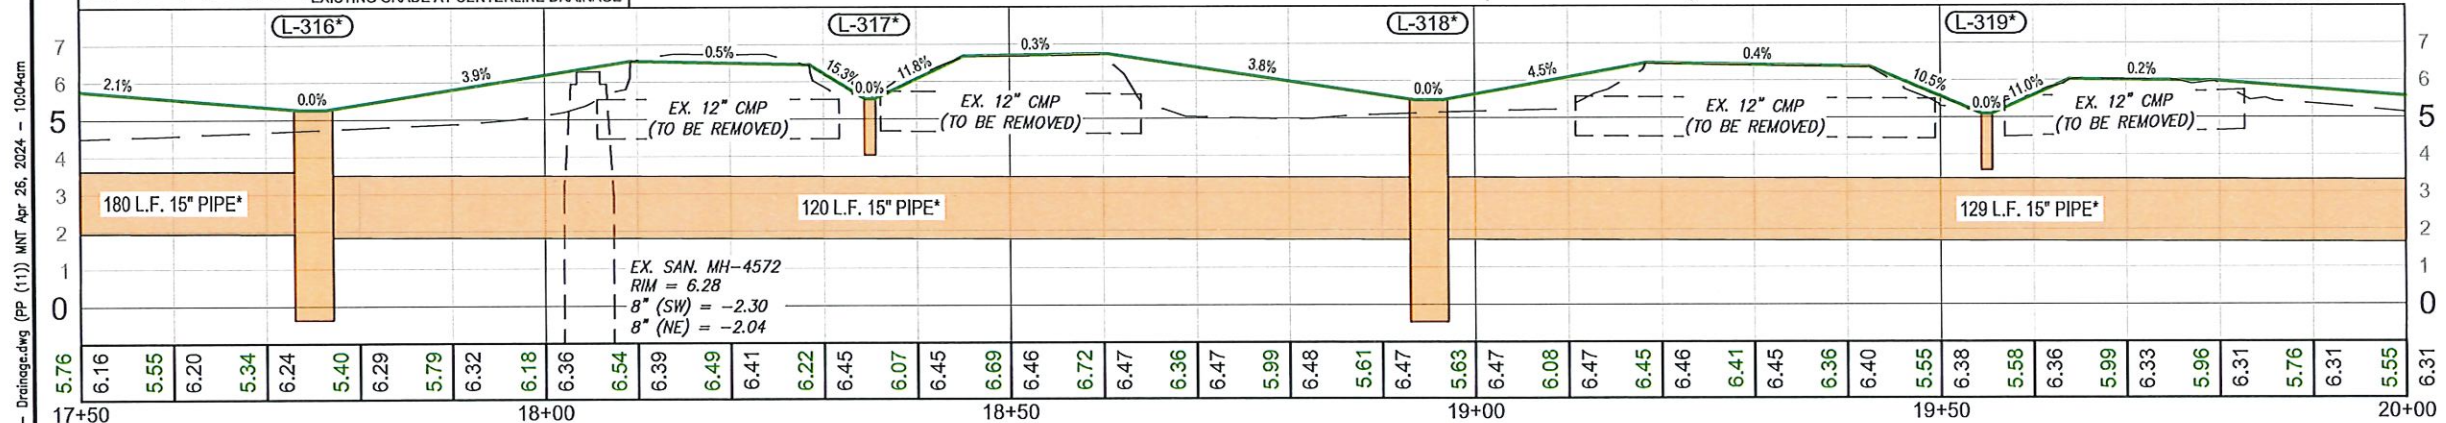

Carlton Street Sta: 17+50 to Sta: 20+00 (RIGHT SIDE)

Hor. Scale: 1" = 20', Vert. Scale: 1" = 5'

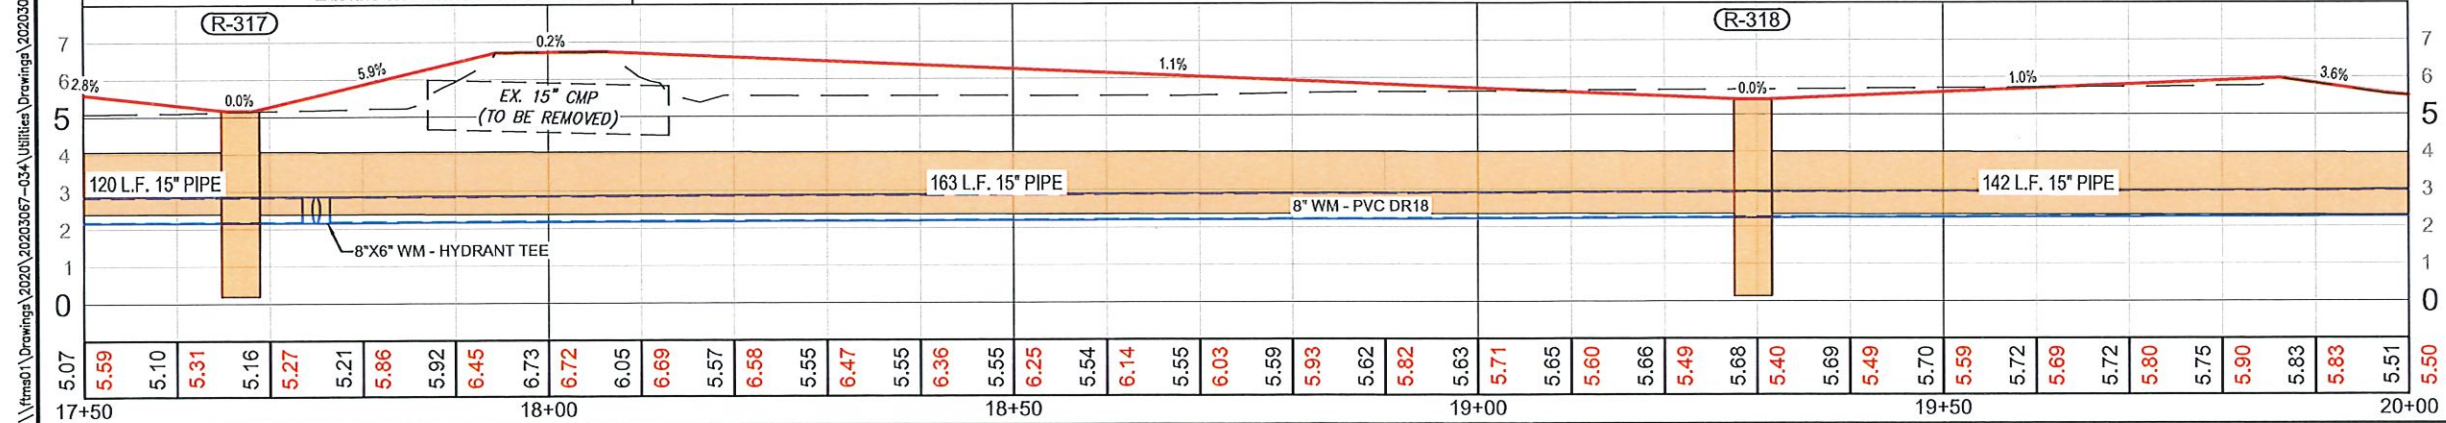

Carlton Street Sidewalk
and Utility Improvements
Collier County, Florida

REVISIONS	
NO.	DESCRIPTION

DATE: April 26, 2024
PROJECT NO. 20203067-034
FILE NO. 50-29-26
SCALE: As Shown

Construction Plans
Drainage Plan &
Profile Carlton Street
Sta 17+50 to 20+00